


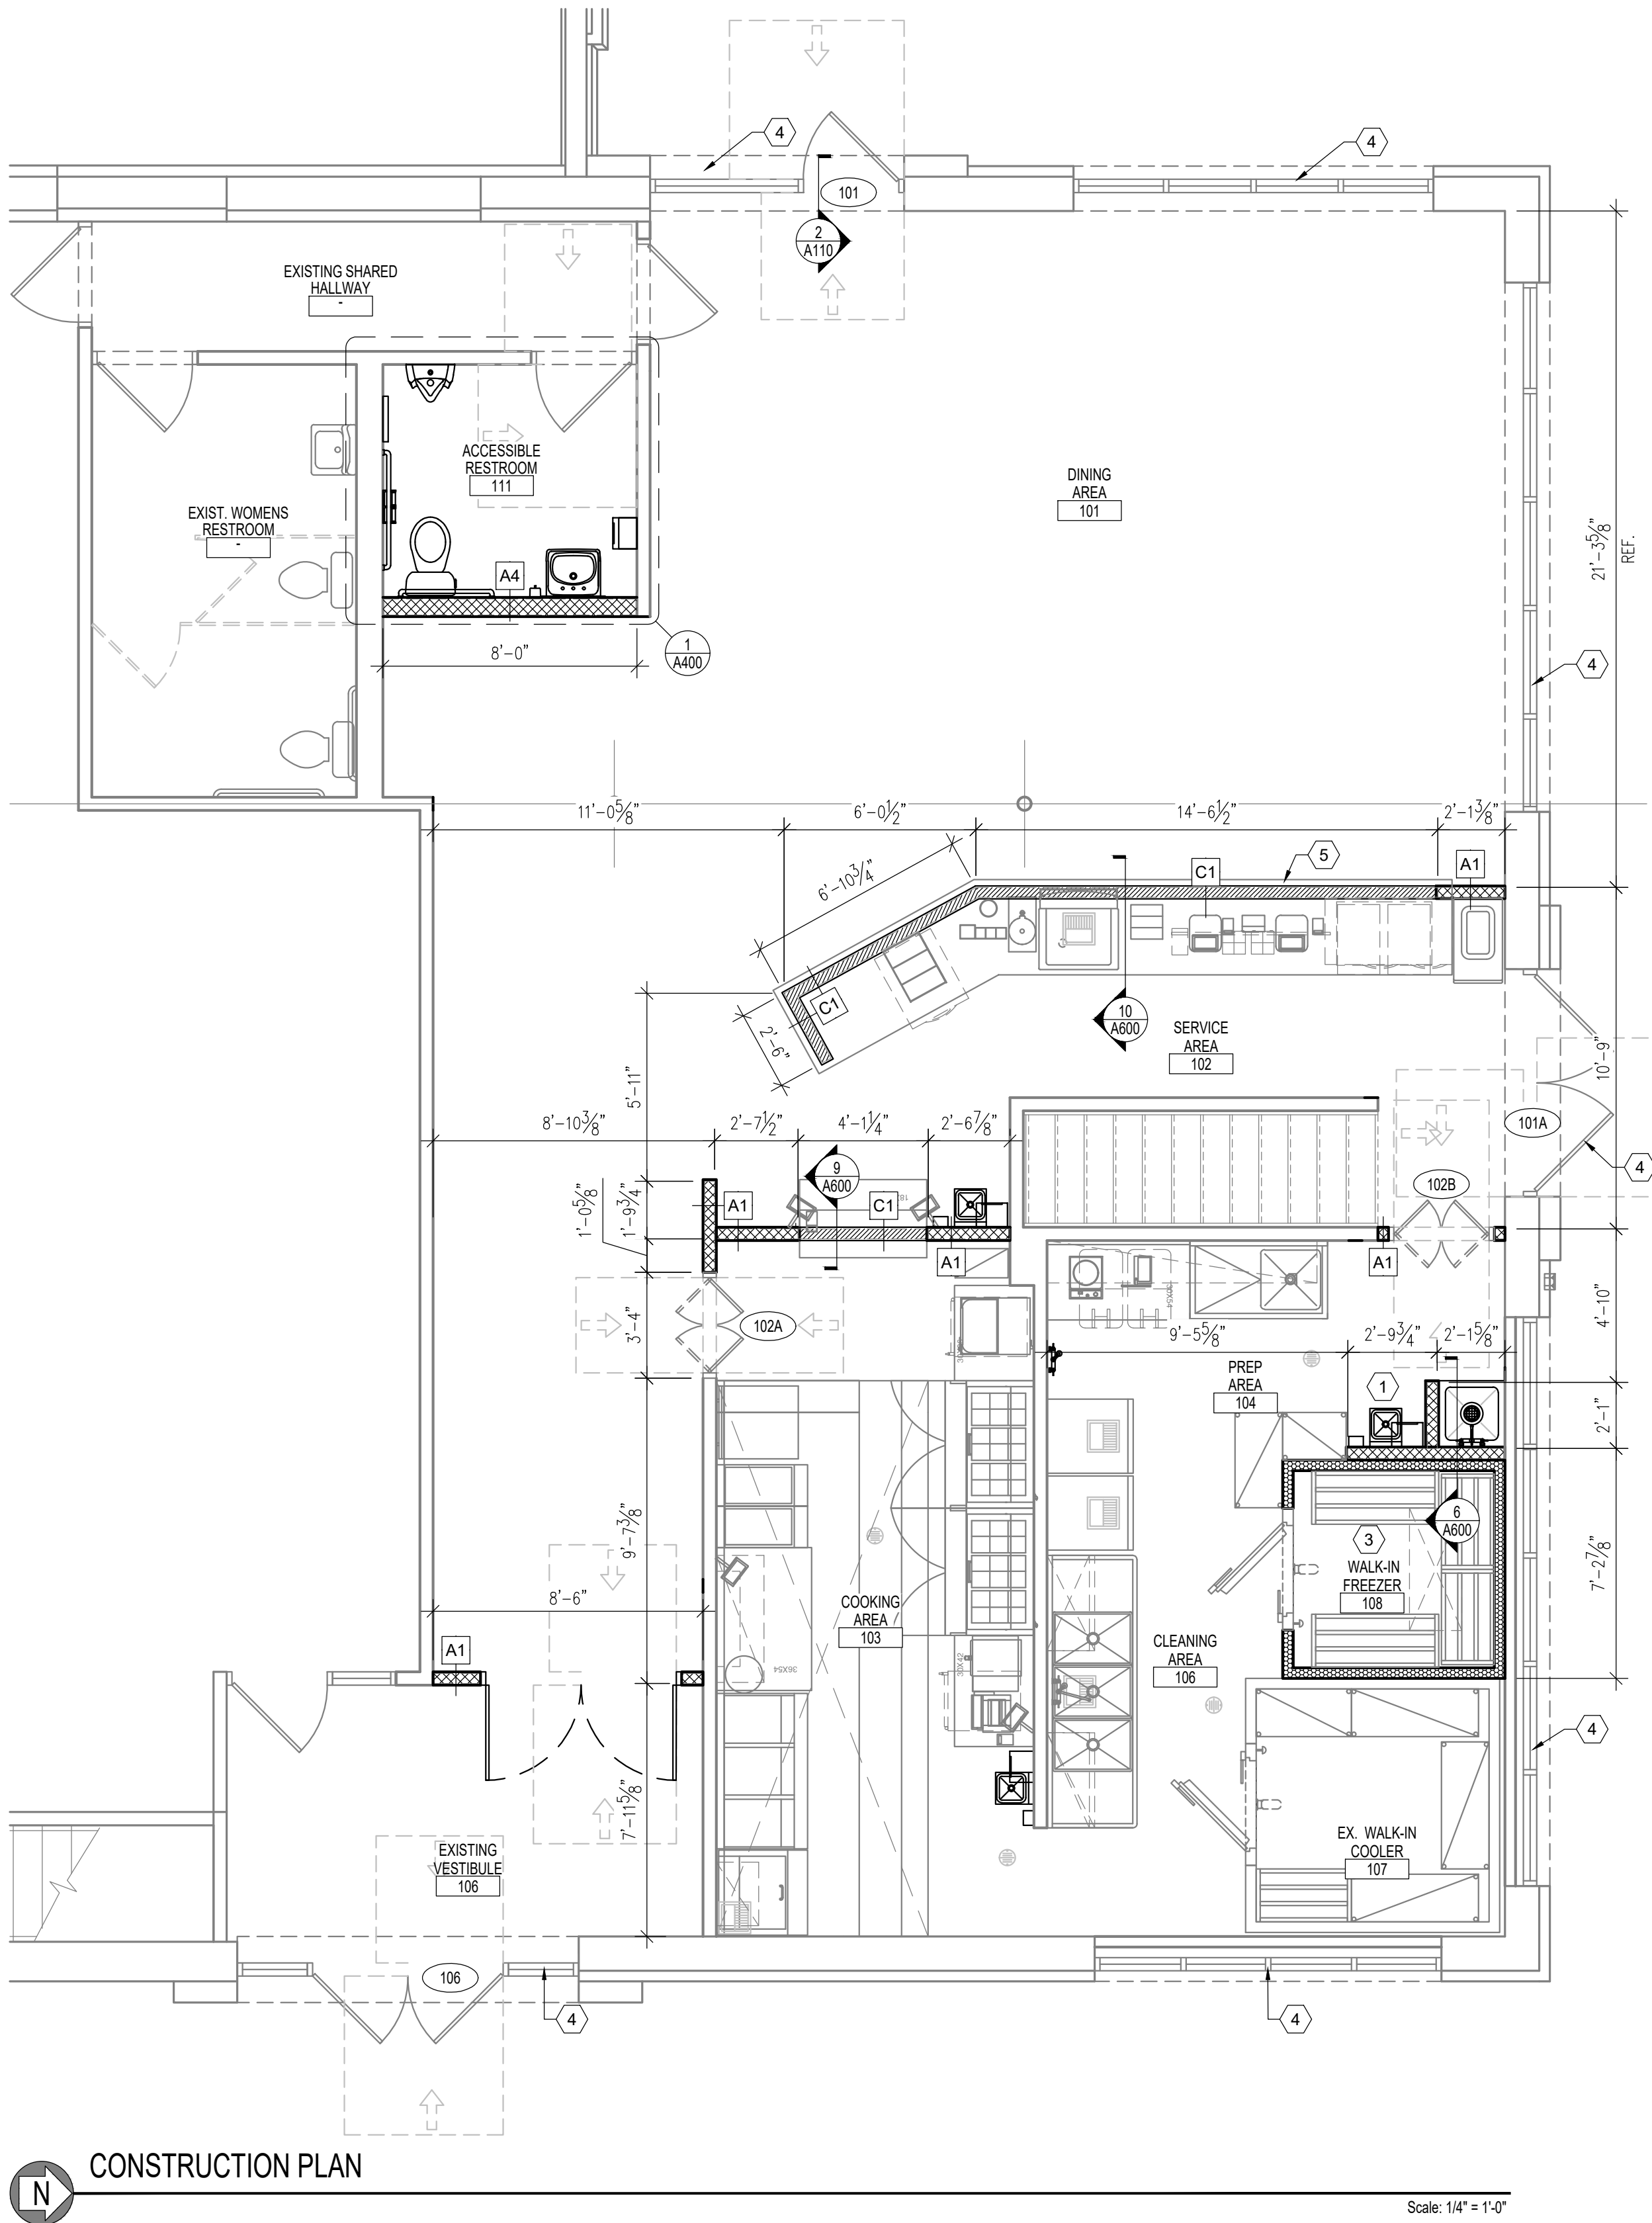


DOOR SCHEDULE							
DOOR				FRAME		HARDWARE GROUP	
DOOR TAG	NEW/EXISTING	SIZE	TYPE	MATERIAL	FINISH		
101	EXISTING	3'-0" X 7'-0" X 1 1/4"	A	AL	AL	AL	GROUP 1
101A	EXISTING	(2) 3'-0" X 7'-0" X 1 3/4"	A	AL	AL	AL	GROUP 1
102A	NEW	3'-0" X 7'-0" X 1 1/4"	D	SS	SS	SS	GROUP 5
102B	NEW	3'-0" X 7'-0" X 1 1/4"	D	SS	SS	SS	GROUP 5
106	EXISTING	(2) 3'-0" X 7'-0" X 1 3/4"	A	AL	AL	AL	GROUP 1

MATERIAL KEY:
AL - ALUMINUM
HM - HOLLOW METAL
SC - SOLID CORE
SS - STAINLESS STEEL

FINISH KEY:
AL - ANODIZED ALUMINUM (CLEAR) TO MATCH EXISTING
PT - PAINTED
CC - CLEAR COAT
SS - STAINLESS STEEL

DOOR TYPES

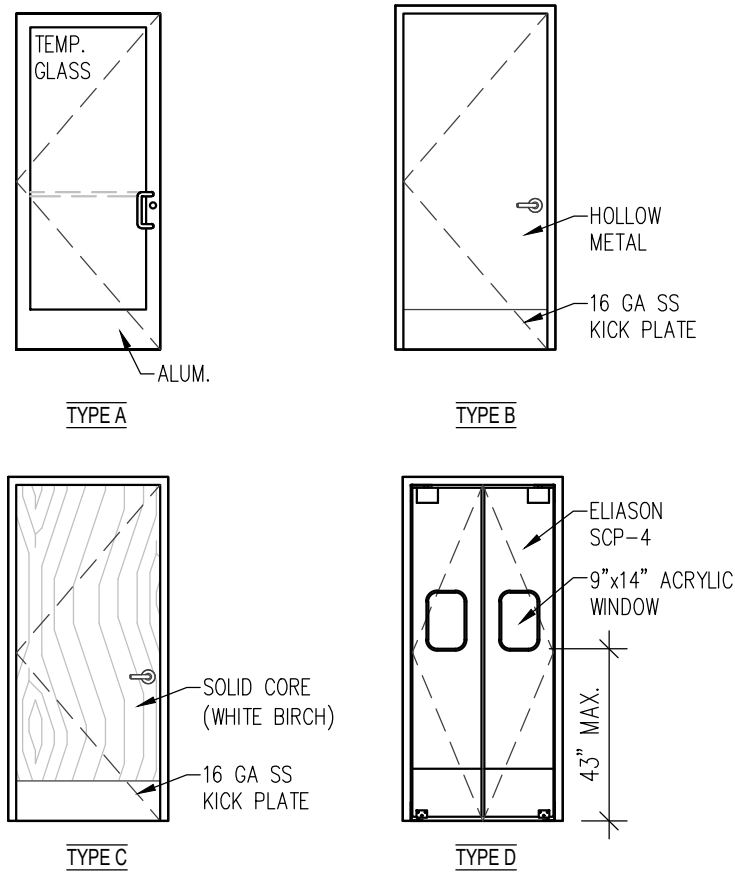

*NOT ALL DOORS SHOWN ARE USED

HARDWARE SCHEDULE

GROUP 1 - ENTRY DOORS (V.I.F. - PROVIDE IF NOT EXISTING)

- 1 EA. EXIT DEVICE PANIC BAR
- 1 EA. LOCK RIM CYLINDER-80-129 VERIFY CAM. & FINISH MAT'L
- 1 EA. CLOSER HEAVY DUTY CLOSER, LCN-4041 (4040 SERIES)
- 1 EA. DOOR PULL KAWNEER - CO-9 (OR EQUAL) - COLOR TO MATCH STOREFRONT
- 1 EA. SIGNAGE SIGNAGE "THIS DOOR TO REMAIN UNLOCKED WHEN THIS SPACE IS OCCUPIED"
- 1 EA. SIGNAGE SIGNAGE "MAXIMUM OCCUPANCY". POST AT MAIN ENTRY THRESHOLD TO MATCH DOOR TYPE AND FLOOR CONDITION (PROVIDE POSITIVE SEAL AGAINST AIR PENETRATION)
- 1 EA. THRESHOLD
- 1 EA. SWEEP PROVIDE DOOR SWEEP TO MATCH THRESHOLD (MATCH STOREFRONT)

GROUP 2 - RESTROOM DOORS PRIVACY SET

- 3 PR. HINGE STANLEY - FBB179 - 4 1/2"x4 1/2"
- 1 EA. LATCH SCHLAGE - ALX-80 PSAT 626 - (PRIVACY HDW.)
- 1 EA. CLOSER DORMA - 7414 AR
- 3 EA. SILENCERS IVES - KP10K34-32D
- 2 EA. KICK PLATE 12"x34" KICK PLATE, 16 GA. SS
- 1 EA. WOMEN'S - SIGN: "WOMEN" (SEE SIGN ON SHEET A400)
- 1 EA. MEN'S - SIGN: "MEN" (SEE SIGN DTL ON SHEET A400)
- 1 EA. UNISEX - SIGN: (SEE SIGN DTL ON SHEET A400)
- 1 EA. STOP FLOOR MOUNTED - ZORO - G2170901 (OR SIMILAR)

GROUP 3 - SERVICE DOOR (V.I.F. - PROVIDE IF NOT EXISTING)

- 3 PR. HINGE STANLEY - CB179 - 4 1/2"x4 1/2"
- 1 EA. LOCK CYLINDER W/ REMOVABLE CORE
- 1 EA. CLOSER HEAVY DUTY CLOSER, LCN-4041 (4040 SERIES)
- 1 EA. ALARM DETEX, EXT ALARM EAX-3500 (FLUSH MOUNTED)
- 1 EA. THRESHOLD PEMKO - #171A - SIZE AS REQUIRED
- 1 EA. SWEEP PEMKO - #307AV - SIZE AS REQUIRED
- 1 EA. WEATHER STRIP PEMKO - 303AV - SIZE AS REQUIRED
- 1 EA. PEEP HOLE PRIME-LINE #U 10314 - SATIN NICKEL FINISH 1" BORE 130° VIEWER
- 1 EA. KICK PLATE 24"x34" (16 GA. STAINLESS STEEL FINISH)

GROUP 4 - OFFICE DOOR

- 3 PR. HINGE STANLEY - FBB179 - 4 1/2"x4 1/2"
- 1 EA. LATCH SCHLAGE - ALX-80 PSAT 626 - (PRIVACY HDW.)
- 1 EA. CLOSER DORMA - 7414 AR
- 3 EA. SILENCERS IVES - KP10K34-32D
- 2 EA. KICK PLATE 12"x34" KICK PLATE, 16 GA. SS
- 1 EA. STOP WALL MOUNTED - DON-JO - 1407-630

GROUP 5 - ELUSON DOOR - MODEL # SCP-4

- 1 EA. HINGE EZ SWING
- 1 EA. WINDOW 9"x14" SINGLE PANE BLACK RUBBER MOLDING
- 1 EA. KICK PLATE 12"H KICK PLATE, 20 GA. SS

- DOOR AND HARDWARE NOTES:
- PERIMETER DOORS TO BE KEYPED ALIKE. PROVIDE KEYWAY AT EXT. FACE.
 - G.C. TO FURNISH & INSTALL CYLINDER IN ALL INTERIOR H.M. DOORS. ALL INTERIOR DOORS TO BE KEYPED ALIKE. PROVIDE KEYWAY AT EXT. FACE.
 - ALL HOLLOW METAL DOOR FRAMES ARE TO BE WELDED.
 - EGRESS DOOR HARDWARE SHALL BE READILY OPERABLE FROM THE EGRESS SIDE WITHOUT THE USE OF A KEY OR SPECIAL KNOWLEDGE OR EFFORT, PER SECTION 1010.1.9.
 - DOOR HANDLES, PULLS, LATCHES, LOCKS AND OTHER DEVICES ON DOORS REQUIRED TO BE ACCESSIBLE SHALL NOT REQUIRE TIGHT GRASPING, TIGHT PINCHING OR TWISTING OF THE WRIST TO OPERATE, PER SECTION 1010.1.9.1. THE OPERATIONAL FORCE SHALL BE AS FOLLOWS: OPERATION BY A FORWARD, PUSHING OR PULLING MOTION = 15 POUNDS MAX., OPERATION BY A ROTATIONAL MOTION = 28 INCH-POUNDS MAX.
 - DOOR STOPS AND BUMPERS TO BE INSTALLED BEHIND ALL DOORS.
 - ALL HDW. TO BE US-260 BRUSHED CHROME, CLEAR ANODIZED FINISH.
 - AT ALL EXISTING DOORS THE CONTRACTOR SHALL VERIFY THAT EXISTING HDW. HAS ALL FUNCTIONS LISTED IN THE HDW. SETS AND IS IN PROPER WORKING ORDER - TO MATCH DAVE'S HOT CHICKEN SPECIFICATIONS.
 - IF A PANIC DEVICE IS PROVIDED, THE EXIT INDICATOR & PUSH BAR ARE NOT REQUIRED.
 - THE BOTTOM 10" OF ALL DOORS TO HAVE A SMOOTH UNINTERRUPTED SURFACE TO ALLOW DOOR TO BE OPENED BY A WHEELCHAIR FOOTREST WITHOUT CREATING A TRAP HAZARDOUS CONDITION

GENERAL NOTES:


- HEALTH DEPARTMENT REQUIRES SNEEZE GUARD TO BE PLACED AT ALL OPEN FOOD AREAS
- MAX EFFORT TO OPERATE DOORS SHALL NOT EXCEED 5 LBS. FOR BOTH EXTERIOR DOORS AND INTERIOR DOORS, SUCH PULL OR PUSH EFFORT BEING APPLIED AT RIGHT ANGLES TO HINGED DOORS. COMPENSATING DEVICES OR AUTOMATIC DOOR OPERATORS MAY BE UTILIZED TO MEET THE ABOVE STANDARDS.
- ADD DUROCK CEMENT BOARD OR EQUAL FROM FINISH FLOOR TO 24" A.F.F. ON ALL KITCHEN WALLS AND BATHROOM WALLS, PROVIDED DUROCK CEMENT BOARD OR EQUAL TOP TO BOTTOM ON ALL WALLS IN MOP SINK STALL.
- VERIFY SEALANT & CONCRETE FLOORING SAMPLE WITH THE CORPORATE CONSTRUCTION MANAGER AND OWNER PRIOR TO INSTALLATION OF ANY MATERIALS. VERIFY CORRECT MOISTURE LEVELS PRIOR TO ANY TILE AND/OR STAINING INSTALLATION.
- SEE ENLARGED RESTROOM PLANS ON SHEET A400 DIMENSIONS, ELEVATIONS, AND DETAILS.
- USE DUROCK CEMENT BOARD OR EQUAL AT WET WALLS & BEHIND PLUMBING FIXTURES.
- PROVIDE BATT INSULATION IN WALLS WHERE SCHEDULED ON WALL TYPES.
- DIMENSIONS ARE FACE OF STUD TO FACE OF STUD, U.N.O.
- ALL GLAZING SHALL BE FIRMLY SUPPORTED ON ALL FOUR EDGES.
- ALL STATIONARY FOOD SERVICE EQUIPMENT MUST BE SEALED TO BOTH CURBS AND WALLS WITH CLEAR CAULK.

LEGEND:


- INDICATES EXISTING WALL, COLUMN, OR CONSTRUCTION TO REMAIN, U.N.O. PATCH + PAINT AS NEEDED
- INDICATES NEW WALL. (SEE WALL ASSEMBLIES)
- INDICATES NEW HALF HEIGHT WALL. (SEE WALL ASSEMBLIES)
- WALK IN COOLER PREMANUFACTURED WALL. (SEE EQUIPMENT PLAN)
- EXISTING STOREFRONT W/ FIXED GLAZING.
- INDICATES NEW AND/OR RELOCATED GLAZING
- STOREFRONT TAG - SEE SHEET A200
- DOOR TAG - SEE SHEET A110
- WALL TYPES - SEE SHEET A111

CODED NOTES

- INSTALL 5/8" PLYWOOD BACKING THROUGHOUT B.O.H. AT NEW WALLS
- CASEWORK BY VENDOR - REFER TO MILLWORK SHOP DRAWING, G.C. TO SIGN OFF PRIOR TO FABRICATION - RE: Q110
- REMOTE CONDENSER RACK TO BE ROOF MOUNTED FOR WALK-IN COOLER AND FREEZER - PROVIDE CONDENSER RACK SIM. TO PRECISION ALUMINUM PRODUCTS INC. - A/C STAND - ROUTE REFRIGERANT LINES FROM ROOF TO WALK-IN(S), SEE MEP ROOF PLAN
- EXISTING STOREFRONT SYSTEM, WINDOW GLAZING & FRAME - EXISTING STOREFRONT DOORS TO REMAIN, G.C. TO VERIFY AND PROVIDE HARDWARE AS SPECIFIED IN DOOR HARDWARE SCHEDULE
- COUNTER TOP BY MILLWORK PROVIDER, RE: 10/A600
- ABOVE CEILING BEVERAGE CHASE - RE: 2/A600

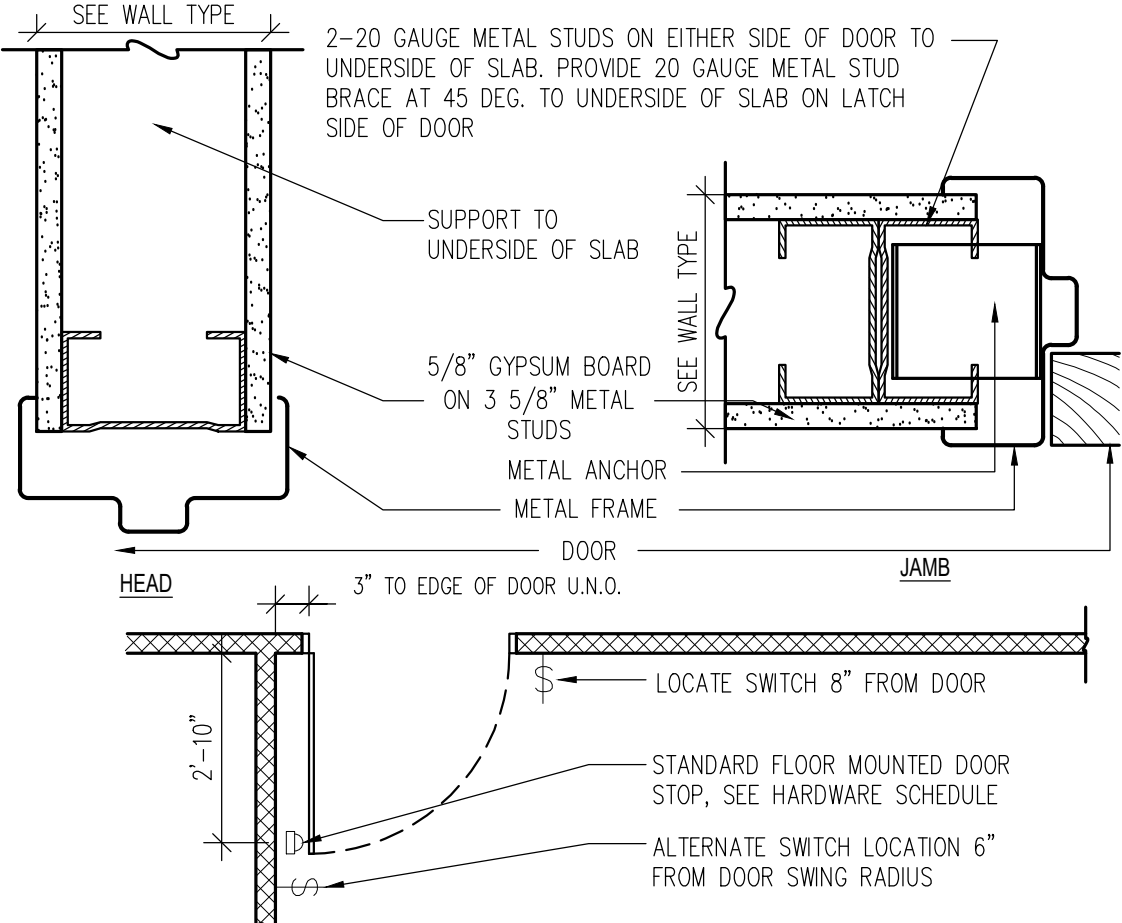

© ALL DRAWINGS AND WRITTEN MATERIAL CONTAINED HEREIN ARE THE PROPERTY OF THE LINGLE DESIGN GROUP, INC. THEY MAY NOT BE REVISED, COPIED, REUSED, OR DISCLOSED IN ANY MANNER WITHOUT WRITTEN AUTHORIZATION FROM THE ARCHITECT.

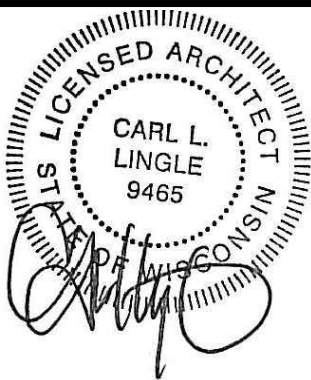

PROJECT #:

23-223

DRAWN BY: EC

CHECKED BY: MP/EC

REVISIONS

- 06/09/23 - DD SET
- 06/28/23 - DD SET UPDATED
- 07/07/23 - DD SET UPDATED
- 07/28/23 - PERMIT SET
- 08/07/23 - CUP SUBMITTAL
-
-



DAVE'S HOT CHICKEN

STORE#

ADDRESS

12345 CAPITOL DR.,
WAUWATOSA, WI 53222

SHEET TITLE

INT. CONSTRUCTION
PLAN & DOOR
SCHEDULE

SHEET NUMBER:

A110