

BUILDING INFORMATION:


PROJECT TYPE:	NEW SINGLE-FAMILY RESIDENCE
ZONED:	SINGLE-UNIT RESIDENTIAL-6 (R1-6)
CONSTRUCTION CLASS:	WOOD FRAME
TAX KEY NUMBERS:	3690428000 3690429000 3690430000
STORIES:	1 PLUS BASEMENT
SPRINKLERED:	NO
CITY:	WAUWATOSA
COUNTY:	MILWAUKEE

AREA BREAKDOWN:

HOUSE	
FIRST FLOOR LIVING AREA:	1,550 S.F.
UNFINISHED LOWER LEVEL:	1,550 S.F.
GARAGE/SHOP	826 S.F.
3-SEASON ROOM	144 S.F.

DRAWING INDEX:

A-00.1	SITE PLAN, AND NOTES
A-1.00	LOWER LEVEL FLOOR PLAN / FOOTING & FOUNDATION PLAN
A-1.01	FIRST FLOOR PLAN
A-1.02	ROOF PLAN
A-1.11	FLOOR FRAMING PLAN
A-1.12	ROOF FRAMING PLAN
A-2.00	EXTERIOR ELEVATIONS, AND FIREPLACE SECTION
A-2.01	EXTERIOR ELEVATIONS
A-4.00	WALL SECTIONS, AND DETAILS
A-4.01	WALL SECTIONS
A-4.02	WALL SECTIONS
A-5.00	INTERIOR ELEVATIONS
A-5.01	INTERIOR ELEVATIONS
LP-1.00	LOWER LEVEL LIGHTING & POWER PLAN
LP-1.01	FIRST FLOOR LIGHTING & POWER PLAN

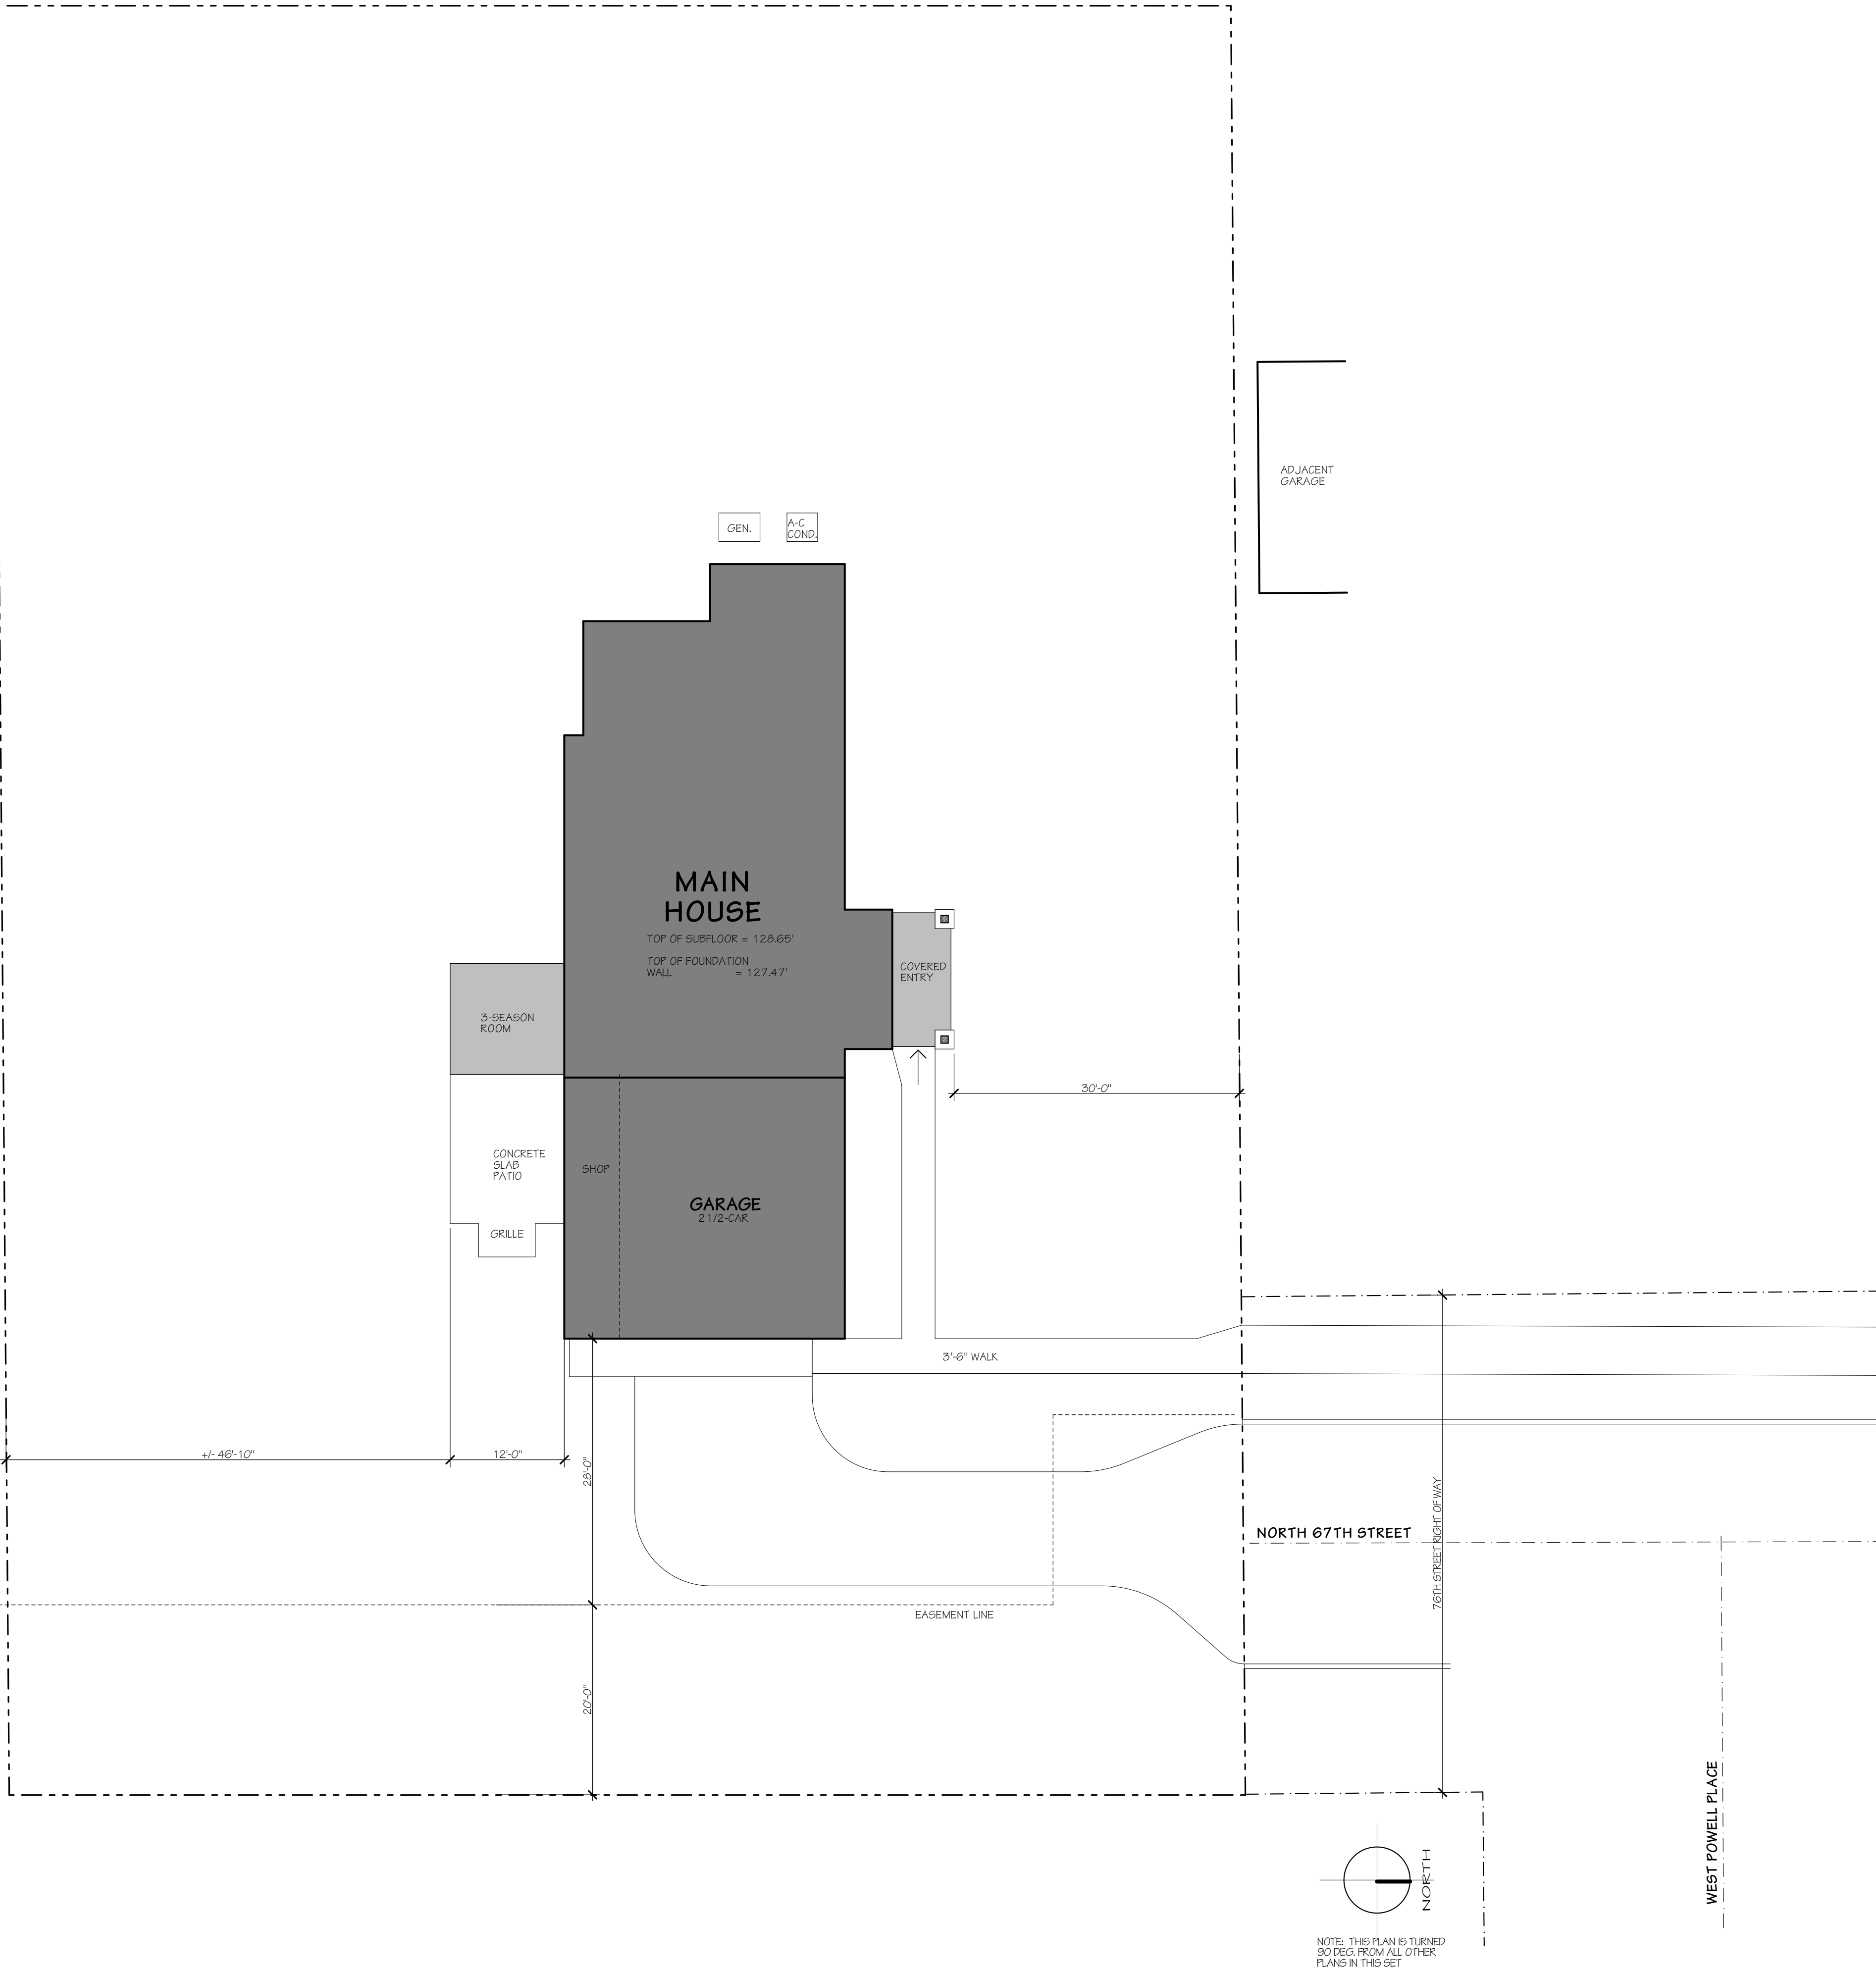


WALL LAYOUT:

- ALL EXTERIOR DIMENSIONS TO STUD WALLS ARE TO THE OUTSIDE FACE OF THE SHEATHING.
- DIMENSIONS TO TIMBER POSTS ARE TO THE CENTER OF POST
- ALL INTERIOR DIMENSIONS ARE TO THE FACE OF 1/2" GYPSUM BOARD.

DRAWING KEY:



- 11 A400 DRAWING NUMBER
12 A400 SHEET NUMBER
13 A400 WALL SECTION KEY
- 14 A400 INTERIOR ELEVATION KEYS
- 15 A400 DOOR NUMBER
- 16 A400 WINDOW NUMBER
- 17 A400 HOSE BIB

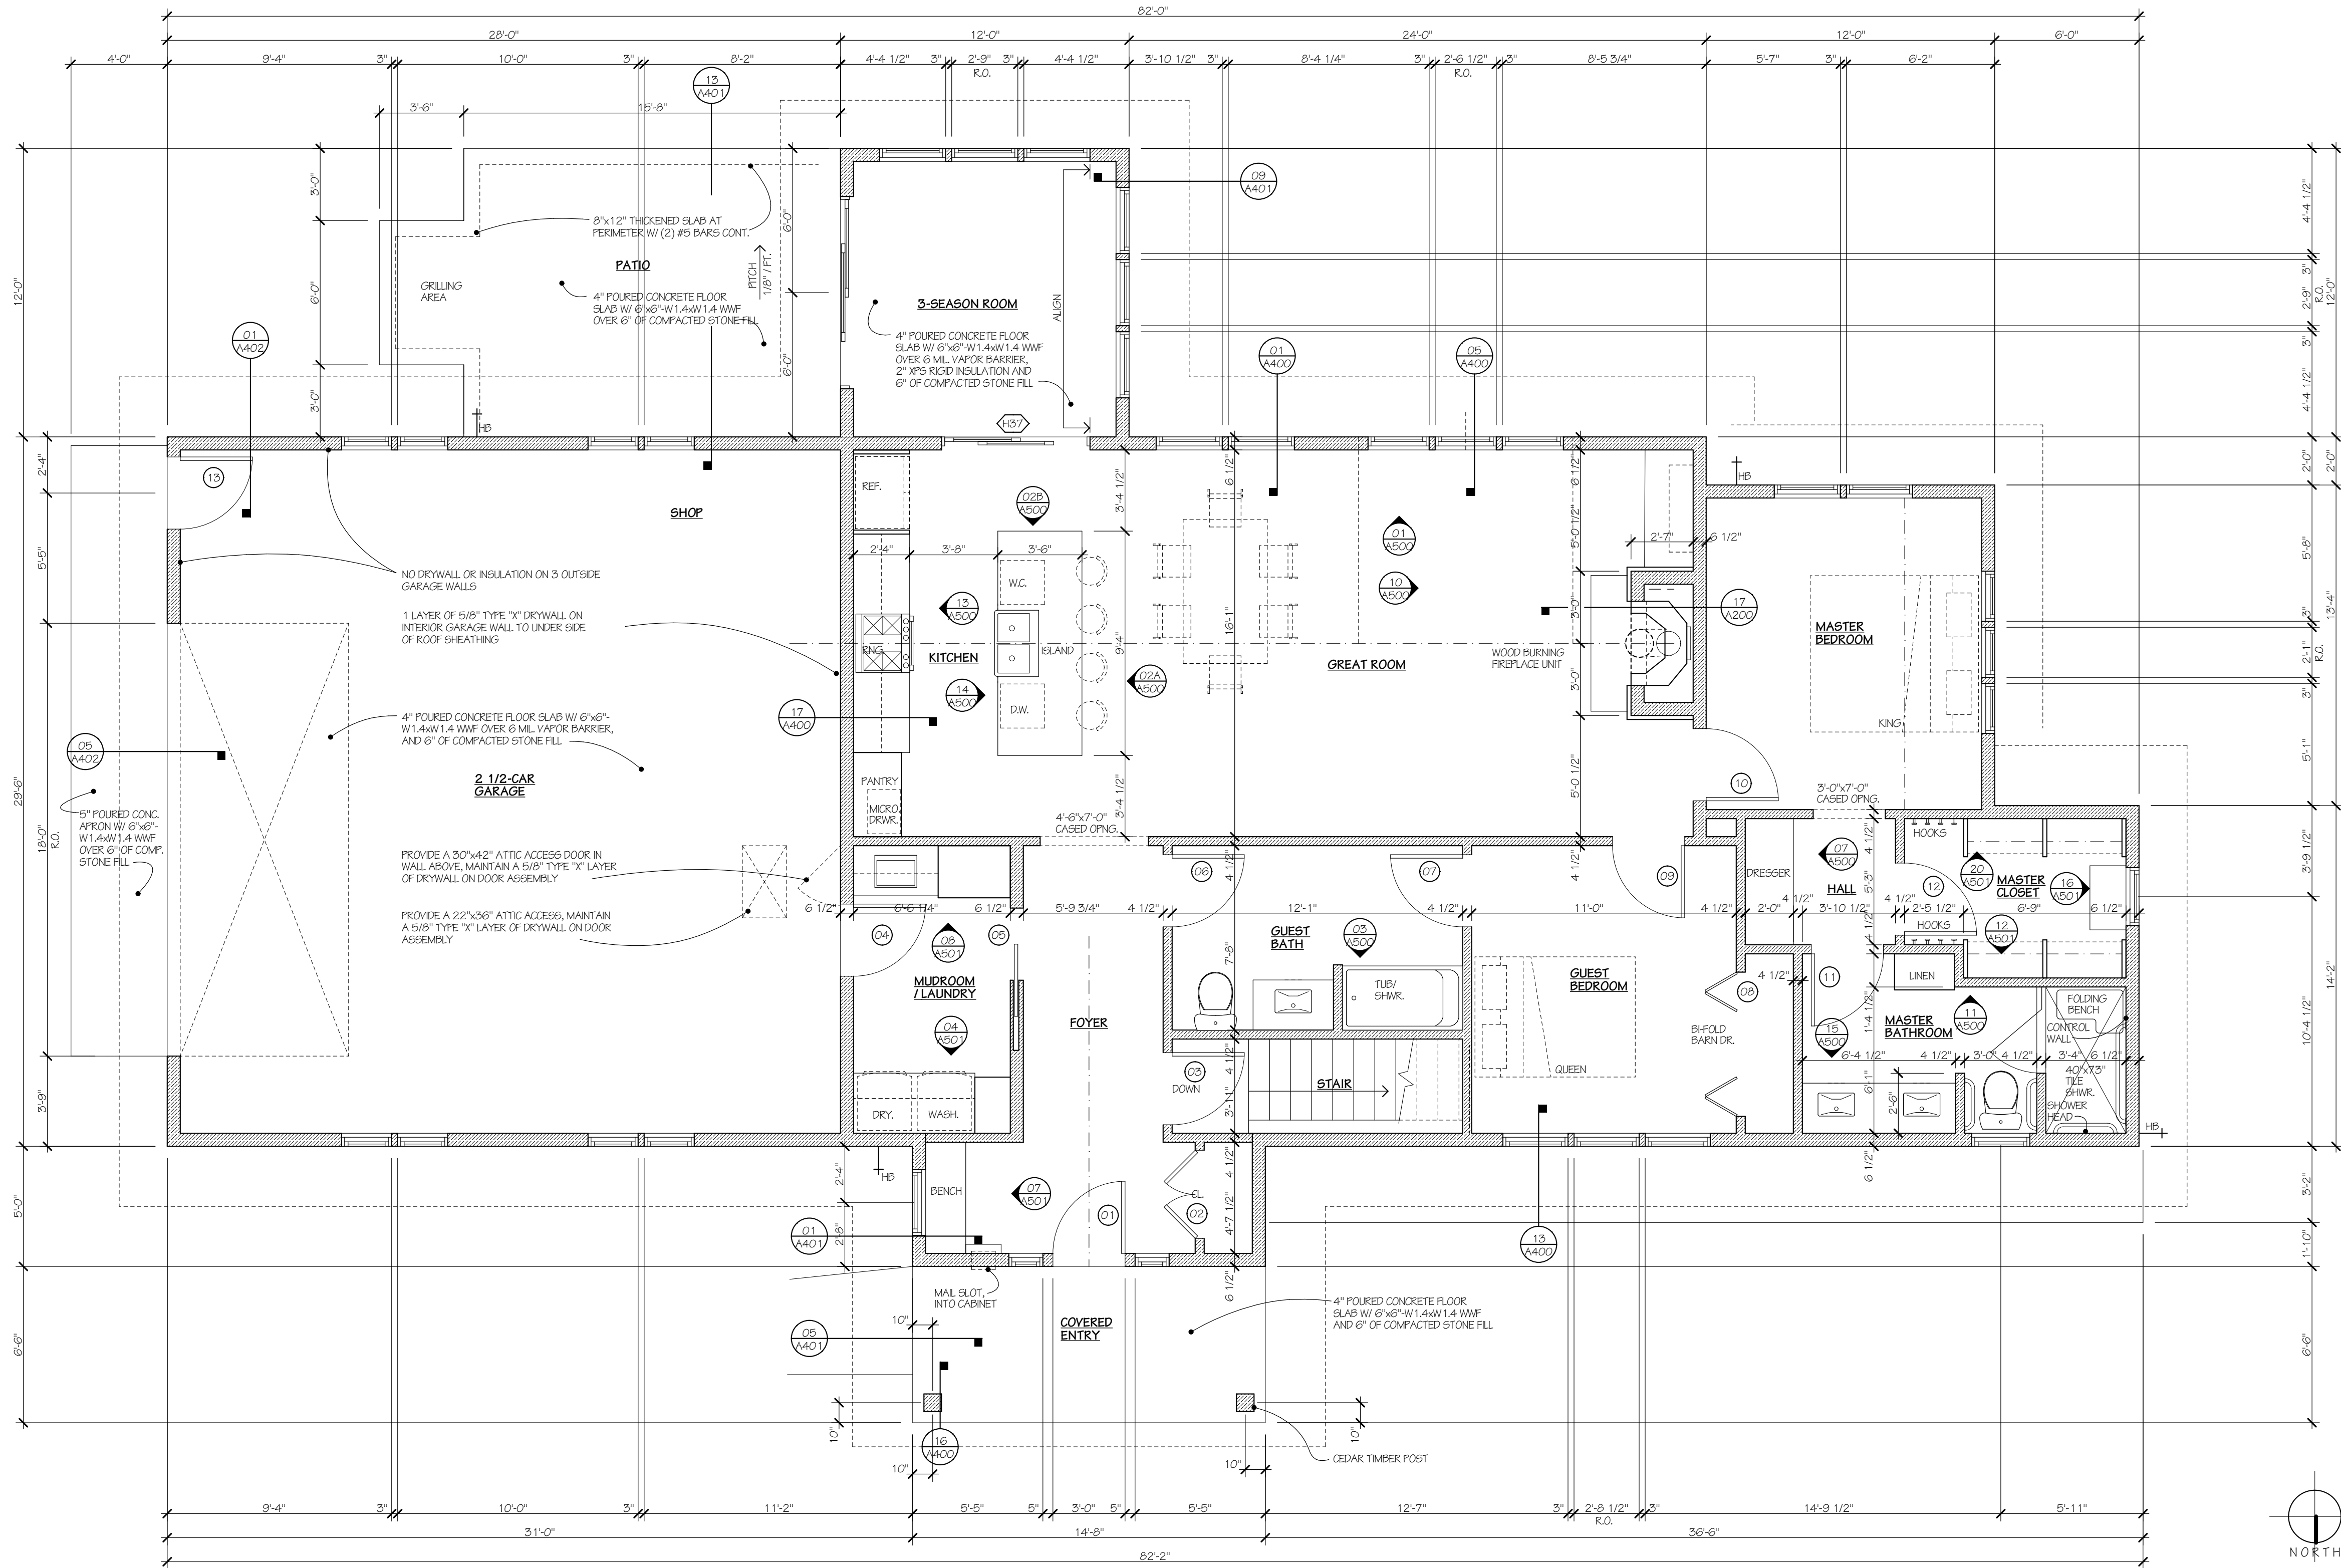


HOUSE - FIRST FLOOR PLAN

1/4" = 1'-0"

01

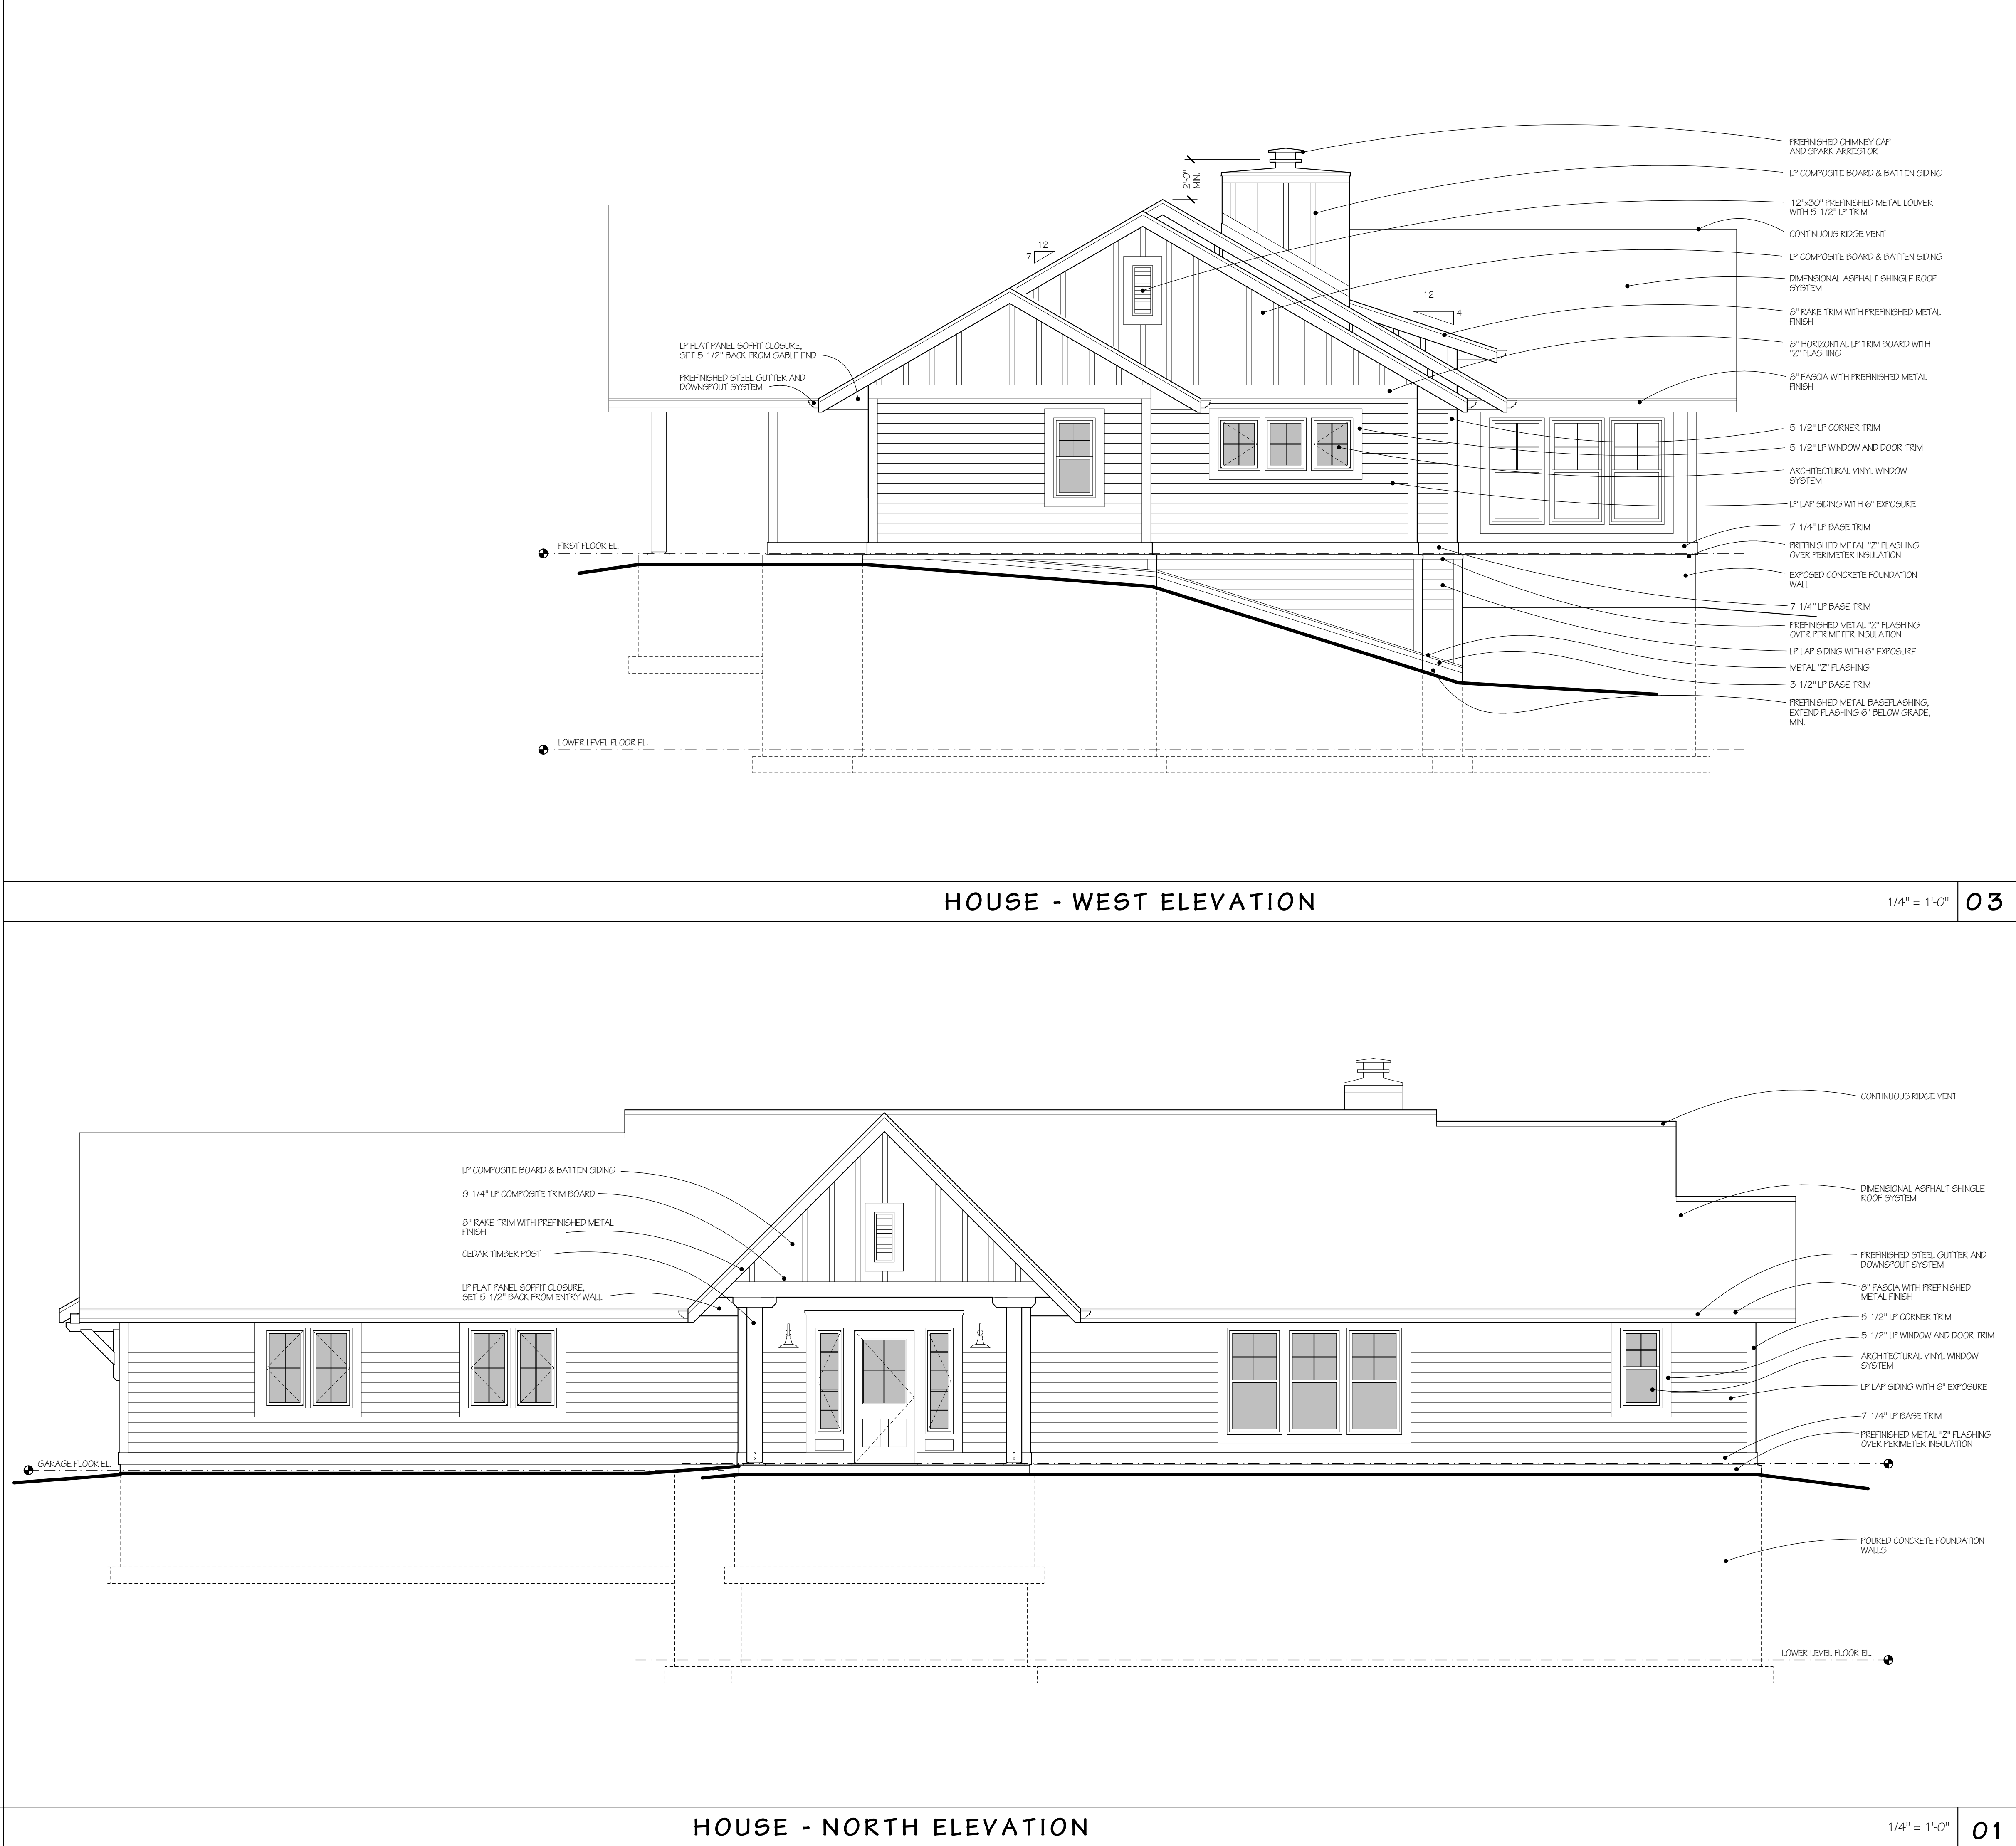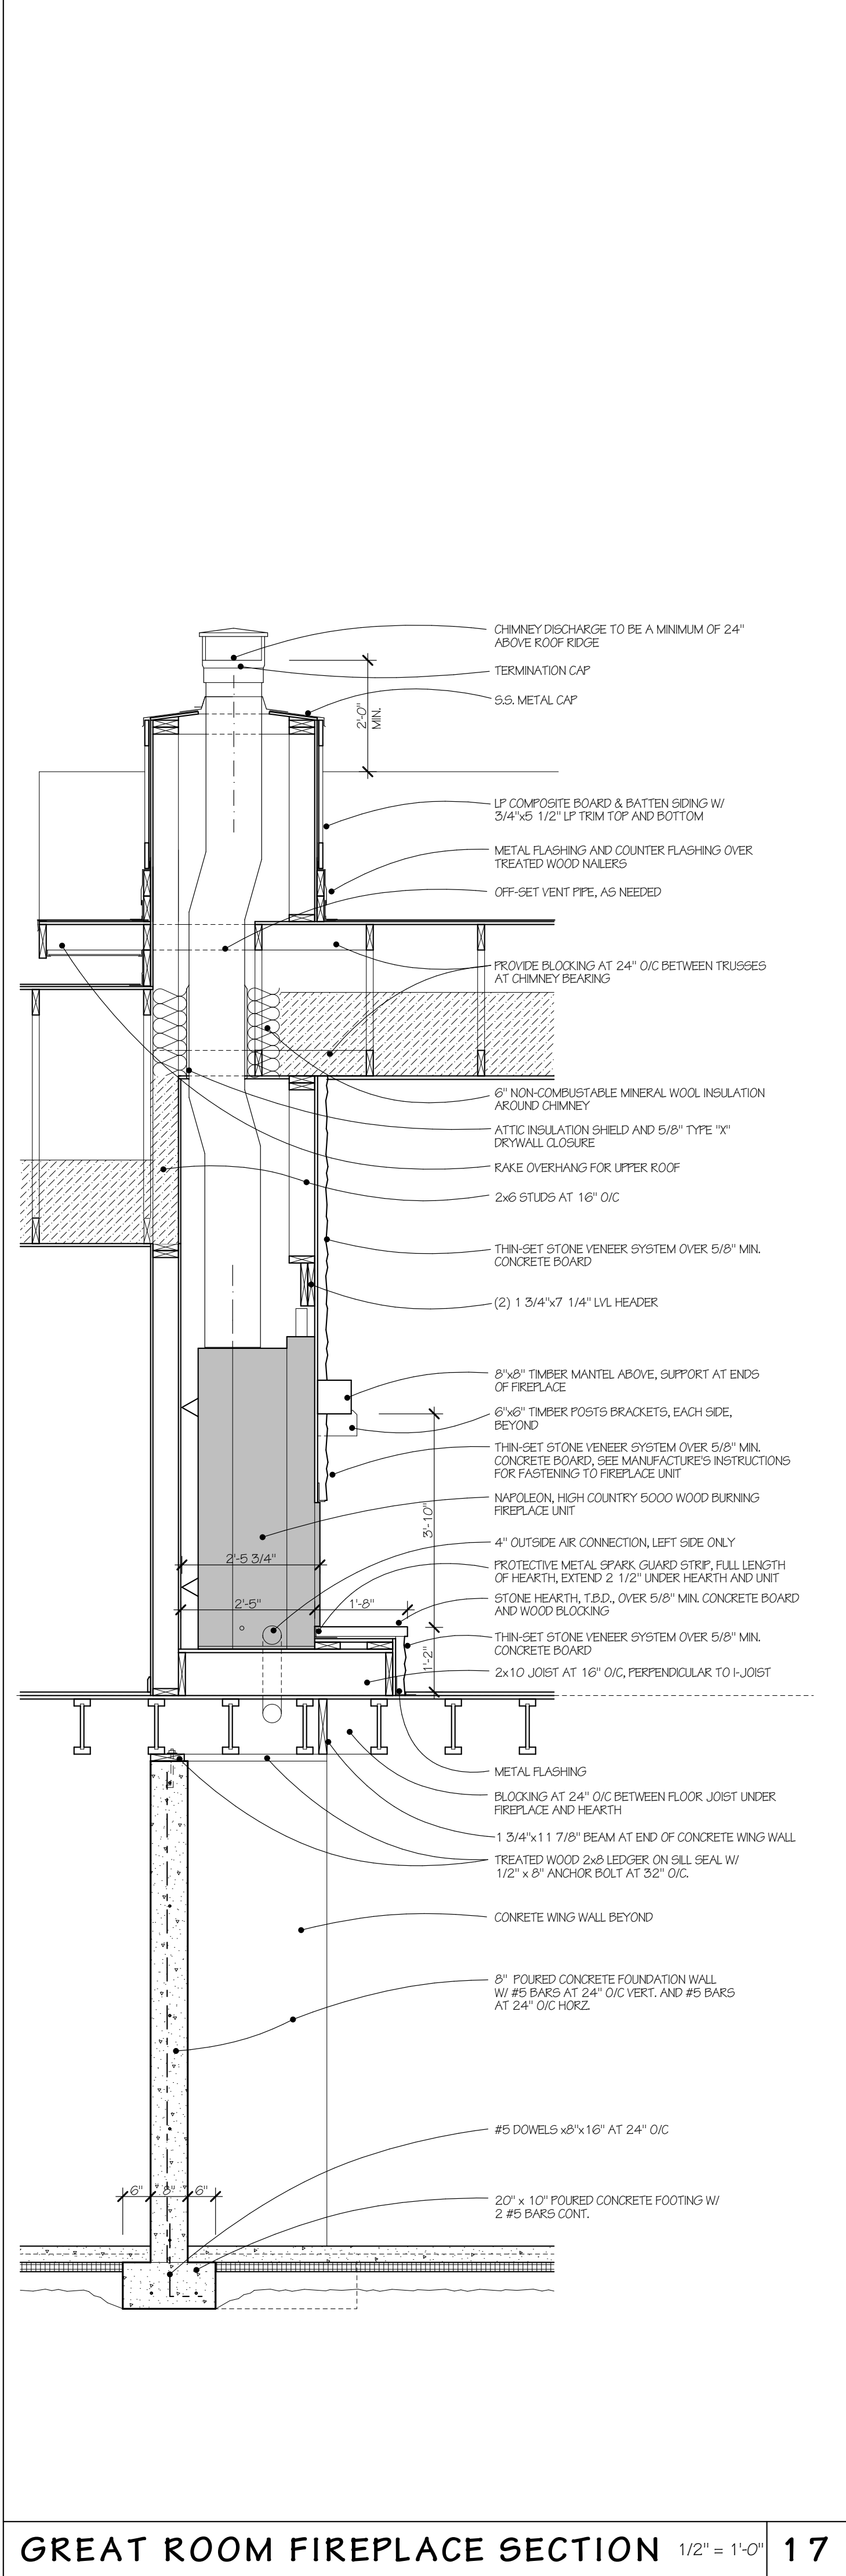

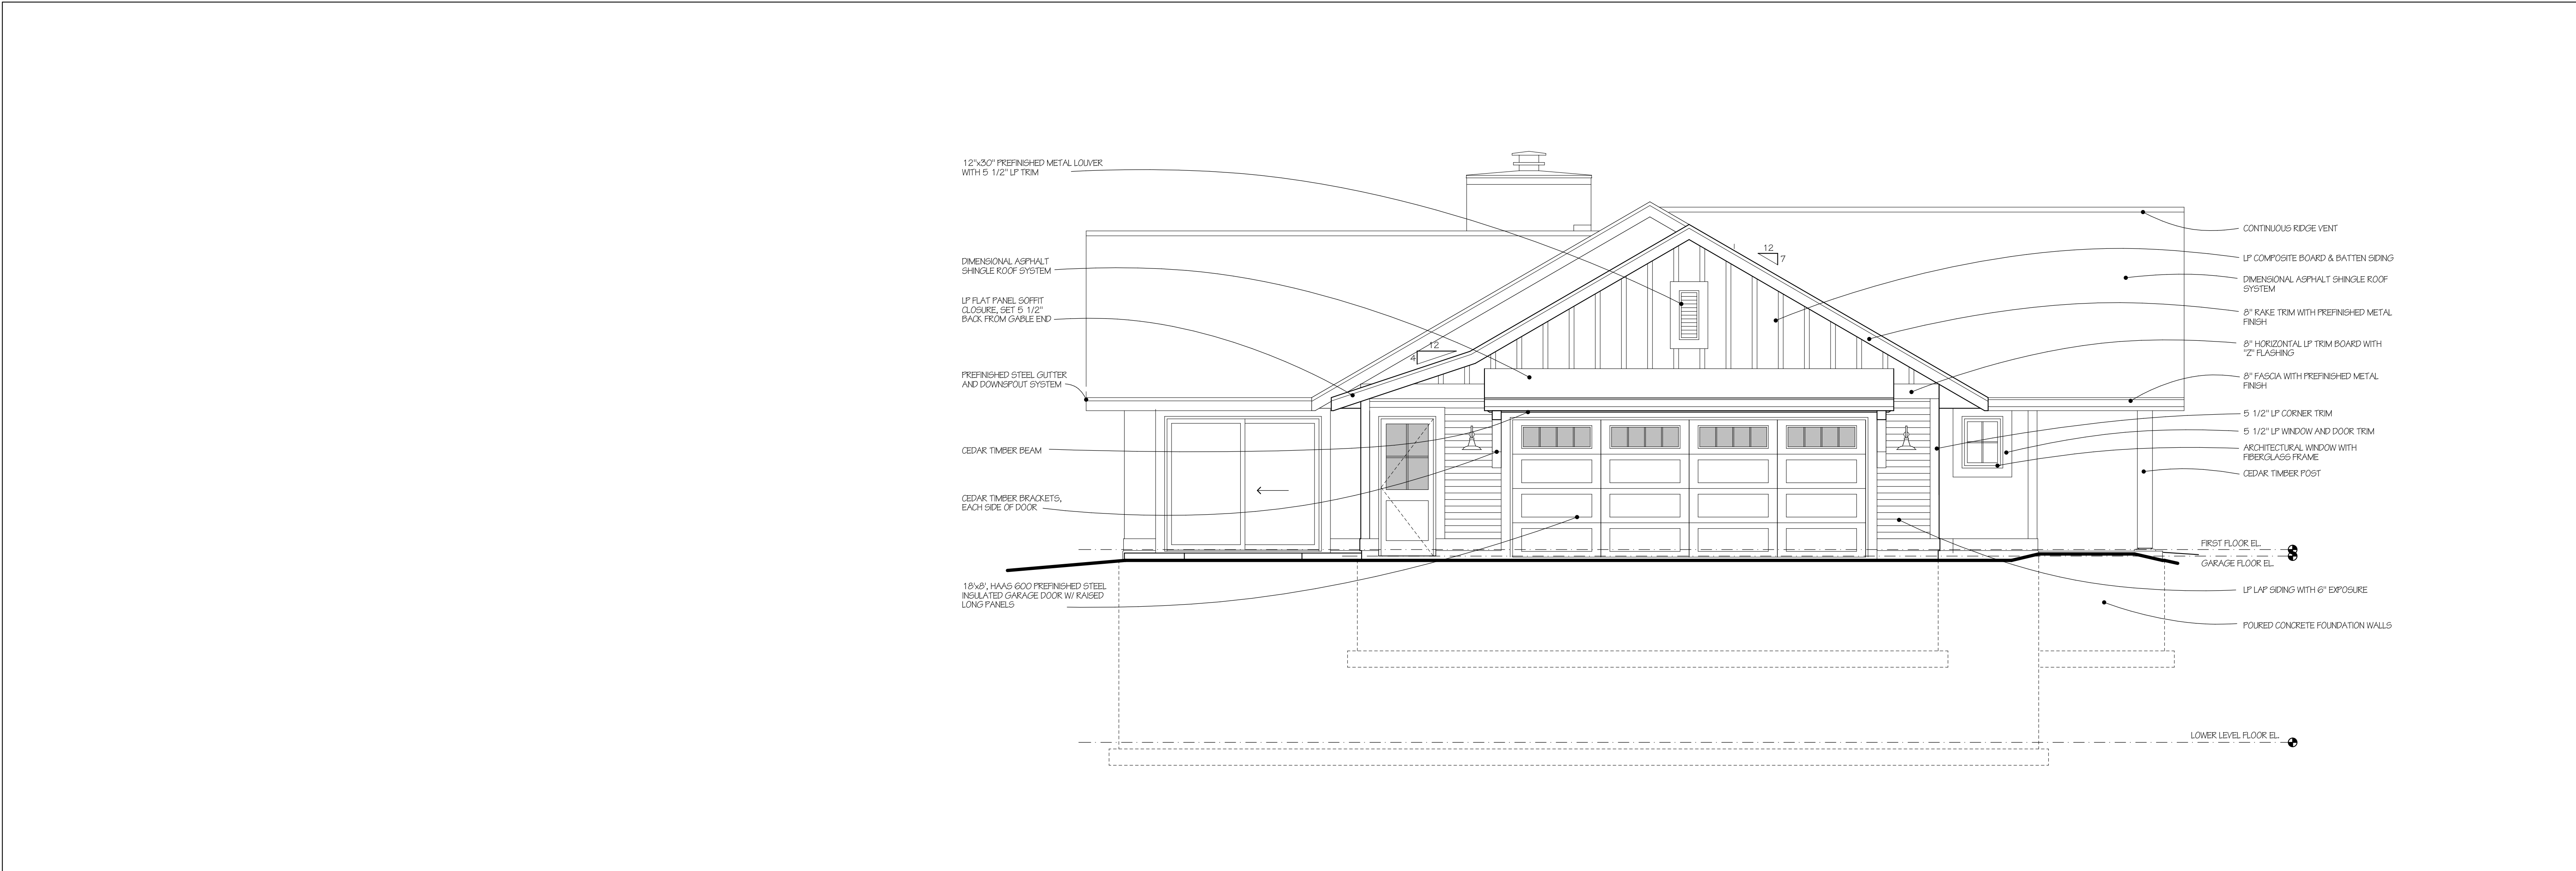

HOUSE - EAST ELEVATION

1/4" = 1'-0" 03



HOUSE - SOUTH ELEVATION

1/4" = 1'-0" 01