

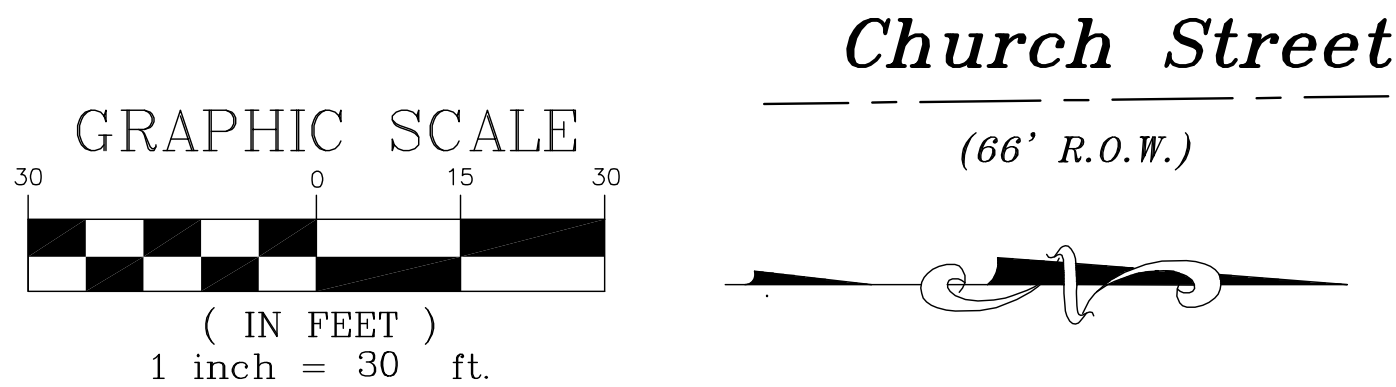


SHEET INDEX	
C11	SITE PLAN
C12	IMAGES
D11	DEMOLITION PLANS
A11	FLOOR PLANS & ROOF PLAN
A41	EXTERIOR ELEVATIONS & SCHEDULES
A42	EXTERIOR ELEVATIONS / SECTION
A51	DETAILS
A61	INTERIOR ELEVATIONS
A62	INTERIOR ELEVATIONS
E11	ELECTRICAL PLANS

DOCUMENT KEY	
	EXISTING WALLS TO REMAIN
	WALLS TO BE REMOVED
	CONVENTIONAL FRAME 2X4 WALL STUDS WITH 1/2" GYP. BD
	MILLWORK ELEMENTS BELOW
	MILLWORK ELEMENTS ABOVE
	CEILING / WALL / SOFFIT ELEMENTS ABOVE
	ITEMS TO BE REMOVED IN DEMOLITION
	INTERIOR ELEVATION MARKER REFER TO SHEETS A6.X FOR ELEVATED VIEWS

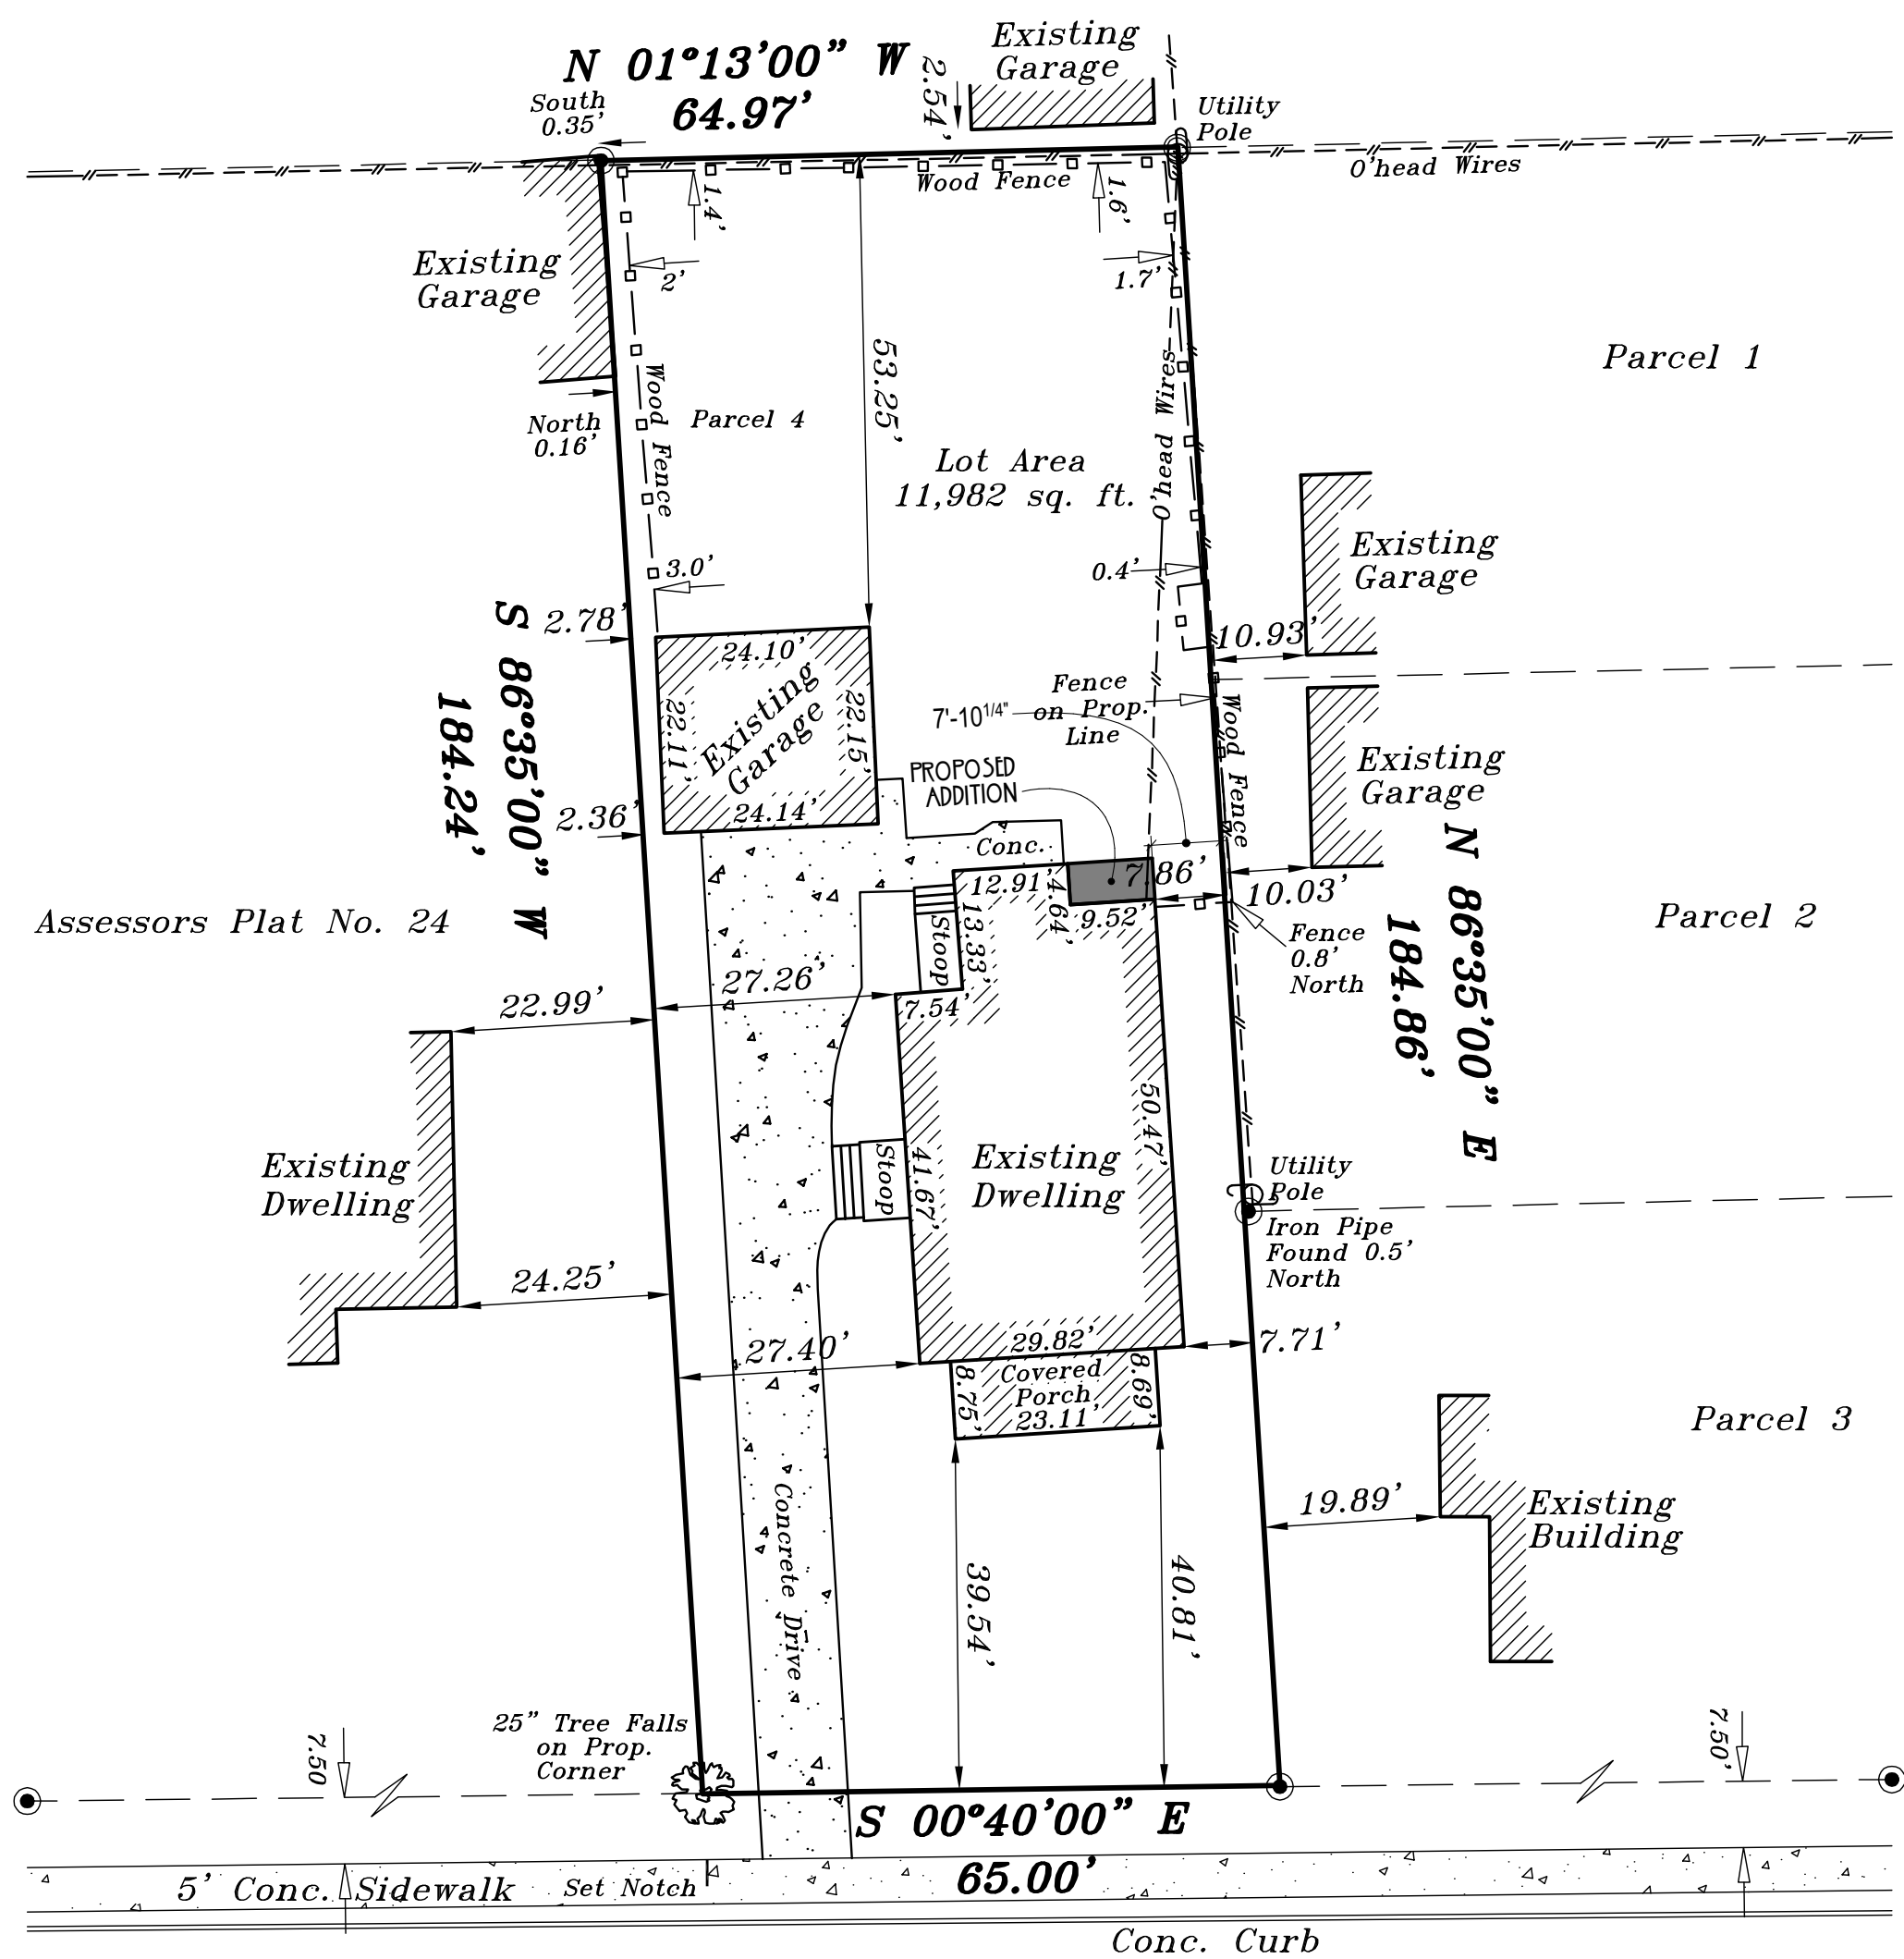

I SITE PLAN
SCALE 1" = 20'

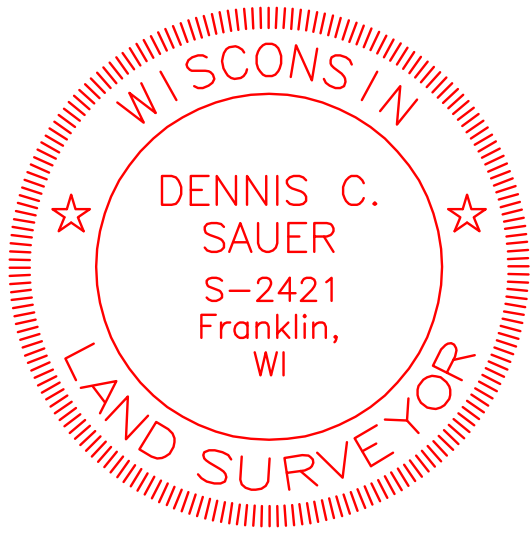

CHURCH ST ADDITION

1621 CHURCH ST
WAUWATOSA, WI 53213
PROJECT NUMBER: 2501

DATE: 11 AUG. 2025

DESCRIPTION: REVIEW SET

SITE PLAN

CU

1

ALAIR

CUSTOM HOMES · RENOVATIONS

PERMITS

PR



2 VIEW FROM NORTH
SCALE 1/8"=1'-0"



1 VIEW FROM SOUTH



3 VIEW FROM WEST
SCALE 1/8"=1'-0"

CL2

IMAGES

DATE: 11 AUG. 2025
DESCRIPTION: CHURCH ST ADDITION
REVIEW SET

1621 CHURCH ST
WAUWATOSA, WI 53213
PROJECT NUMBER: 2501

A L A I R
CUSTOM HOMES · RENOVATIONS



P E N & H
A M M E R



REMOVE WINDOWS
AND WALL BELOW FOR
NEW BASEMENT ACCESS

1


 
 
 
BASEMENT
LAUNDRY

BASEMENT
HALL

CLOSET

BASEMENT
STORAGE



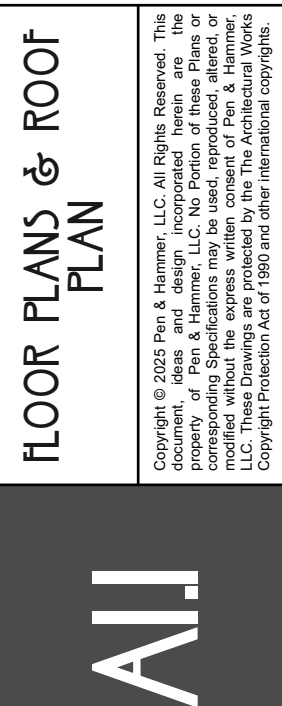

A L A I R



PERNÄWER

CUSTOM HOMES · RENOVATIONS

CHURCH ST ADDITION

1621 CHURCH ST
WAUWATOSA, WI 53213
PROJECT NUMBER: 2501

DATE	DESCRIPTION
14 AUG. 2025	REVIEW SET

FLOOR PLANS & ROOF PLAN

Copyright © 2025 Pen & Hammer, LLC. All Rights Reserved. This document, ideas and design incorporated herein are the property of Pen & Hammer, LLC. No Portion of these Plans or corresponding Specifications may be used, reproduced, altered, or modified without the express written consent of Pen & Hammer, LLC. These Drawings are protected by The Architectural Works Copyright Protection Act of 1990, and other international copyrightable.




1 SOUTH ELEVATION
SCALE 1/4" = 1'-0"


EXTERIOR ELEVATION NOTES			
01	NEW WOOD SIDING WITH CORNER BOARDS TO MATCH EXISTING		
02	NEW ASPHALT ROOF SHINGLES TO MATCH EXISTING		
03	NEW WINDOWS WITH TRIM TO MATCH EXISTING		
04	RAKE & TRIM TO MATCH EXISTING		
05	GUTTER AND RETURN WITH CROWN AND TRIM ON SOFFIT - MATCH EXISTING		
06	STUCCO OVER CEMENT BOARD, TEXTURE TO MATCH EXISTING		
07	LOWER 2X TRIMS - MATCH EXISTING		
		SHADED AREA INDICATES EXISTING MATERIALS TO REMAIN	

DOOR SCHEDULE			
MARK	DOOR		NOTES
	W	HT	
D1	2'-10"	6'-8"	POCKET DOOR
D2	3'-2"	6'-8"	
D3	2'-6"	6'-8"	EXIST DOOR REMOVED AND CONVERTED TO WIDENED C.O.


WINDOW SCHEDULE			
MARK	SIZE		NOTES
	WIDTH	HEIGHT	
101	4'-8"	4'-4"	DOUBLE WINDOW
201	2'-4"	3'-8"	
202	2'-4"	3'-6"	
X	2'-0"	2'-0"	

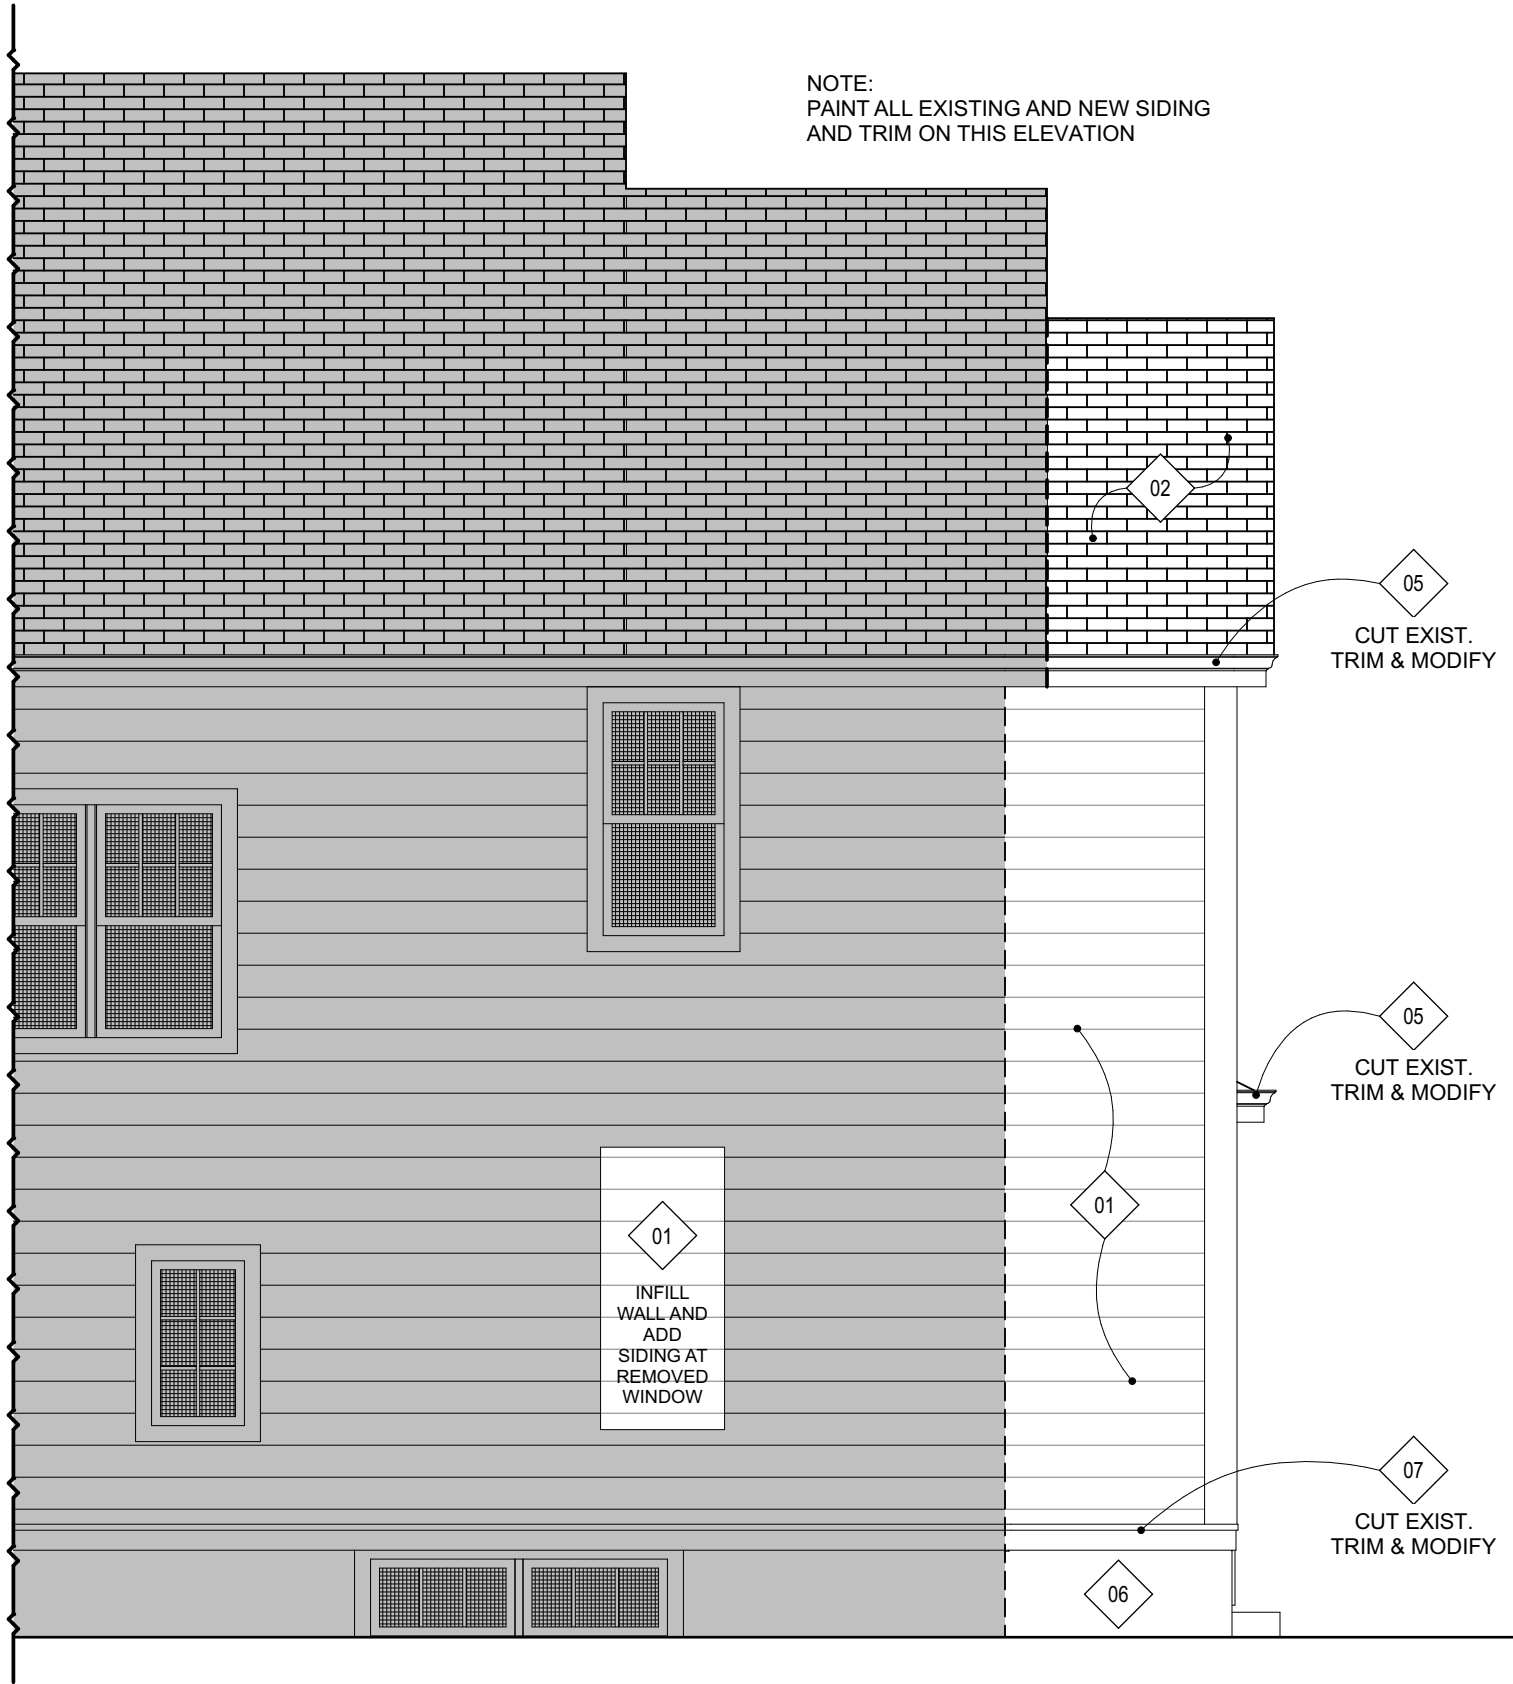


2 NORTH ELEVATION
SCALE 1/4" = 1'-0"

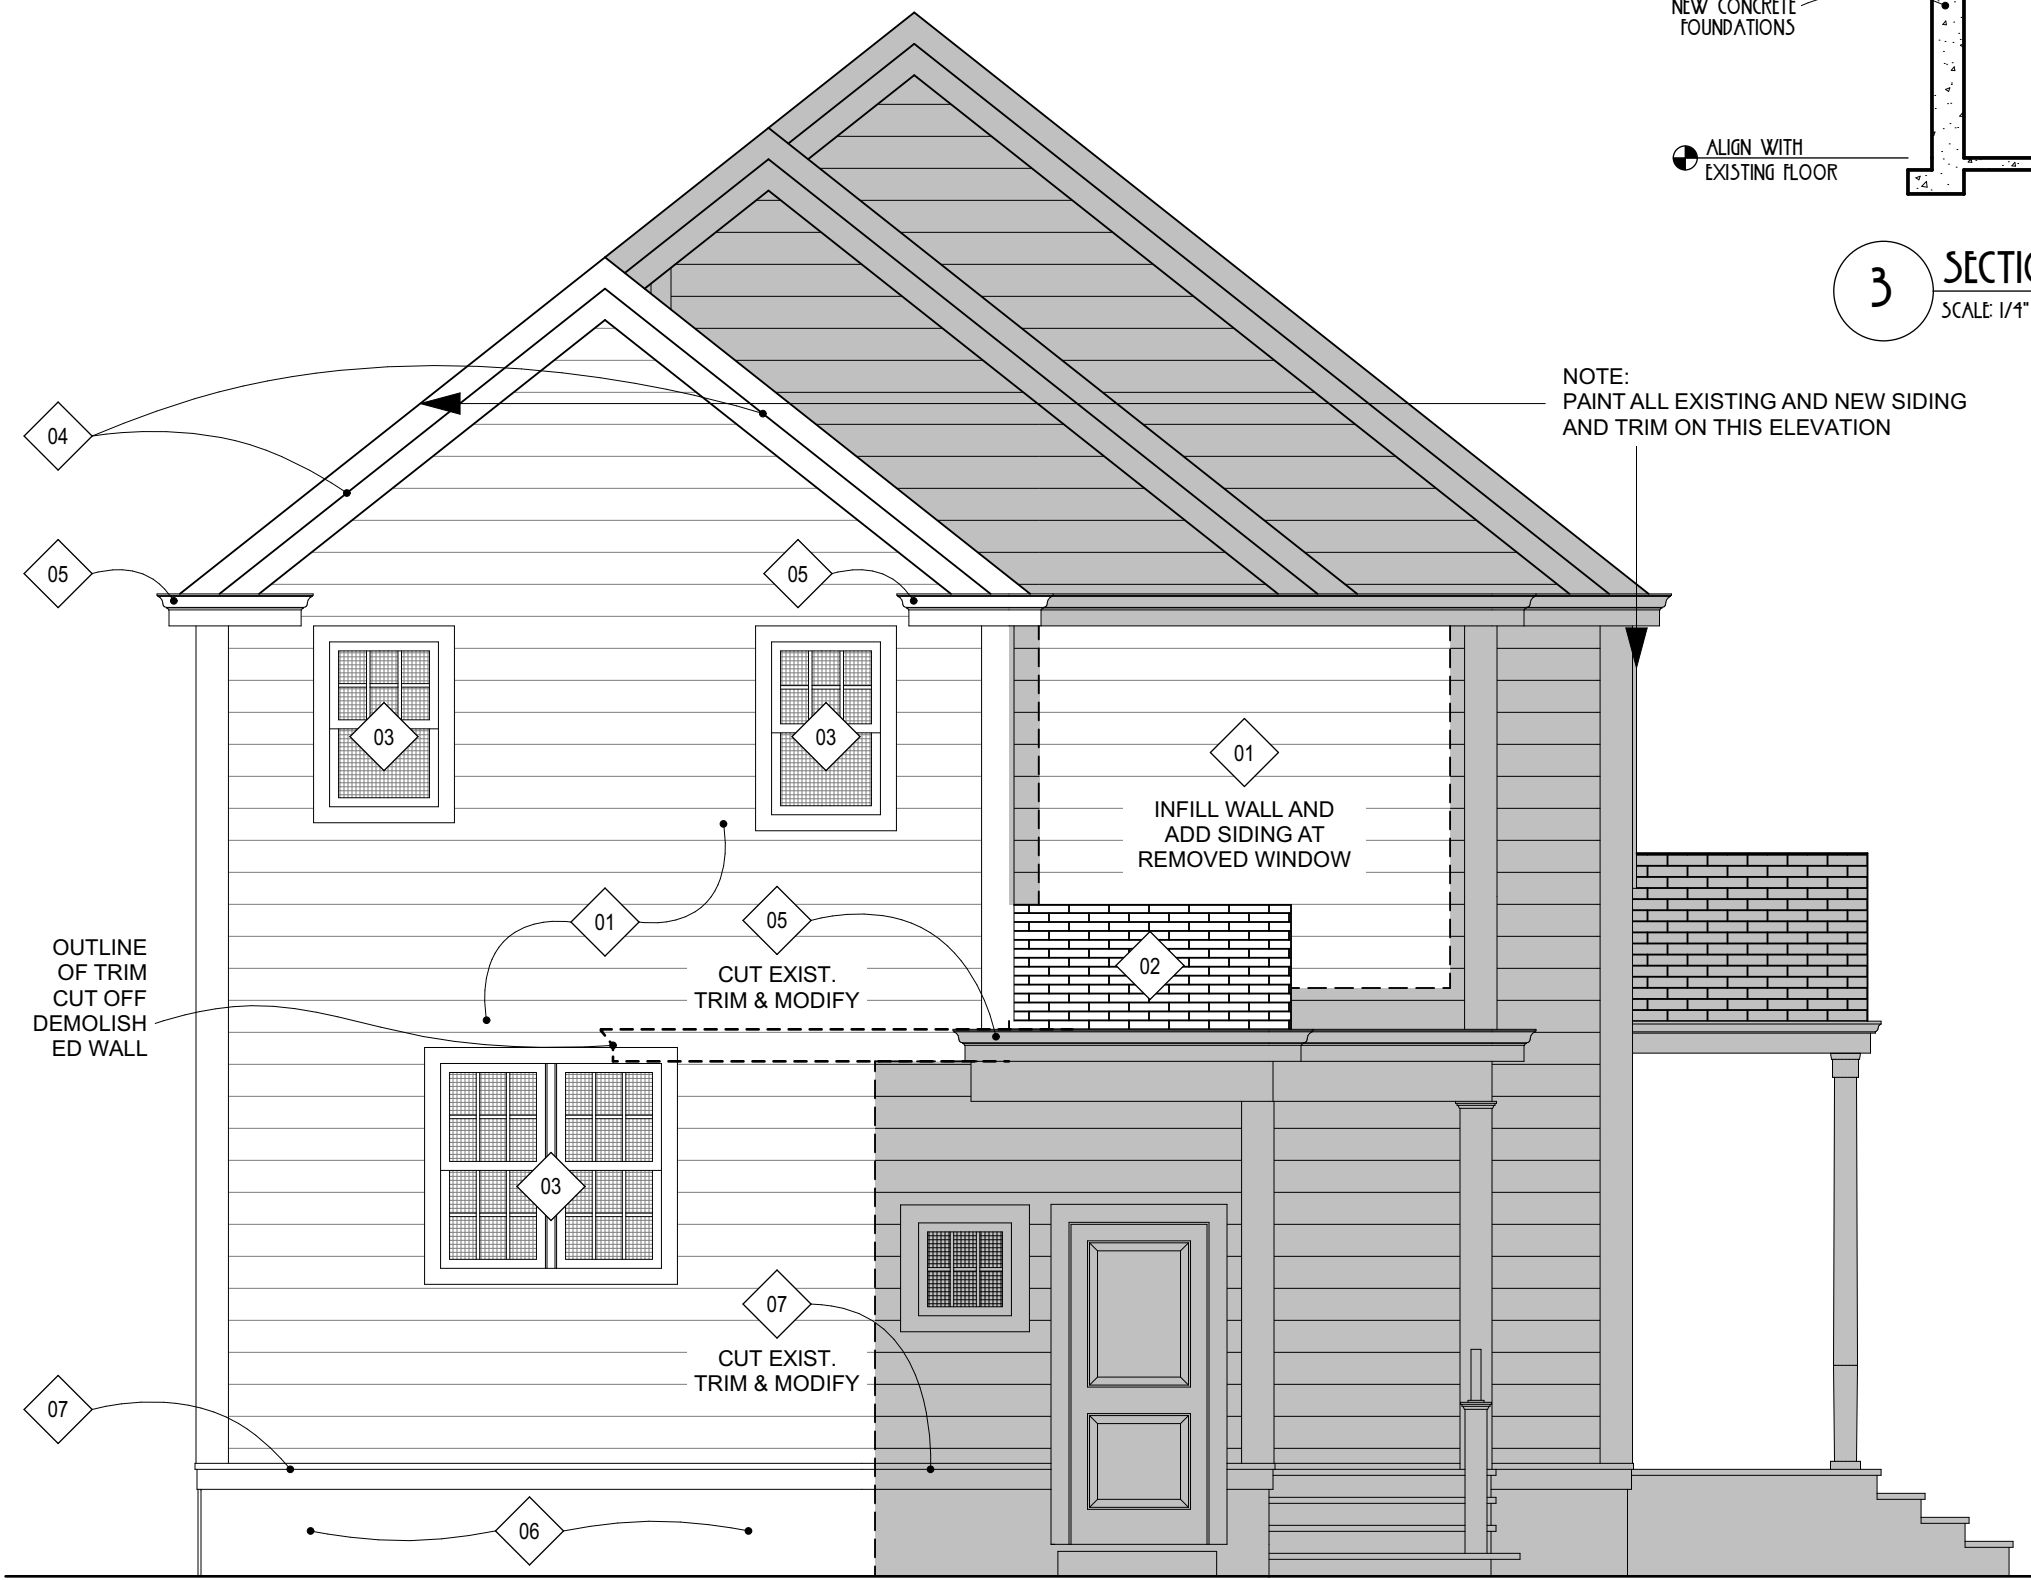

1 WEST ELEVATION
SCALE 1/4" = 1'-0"

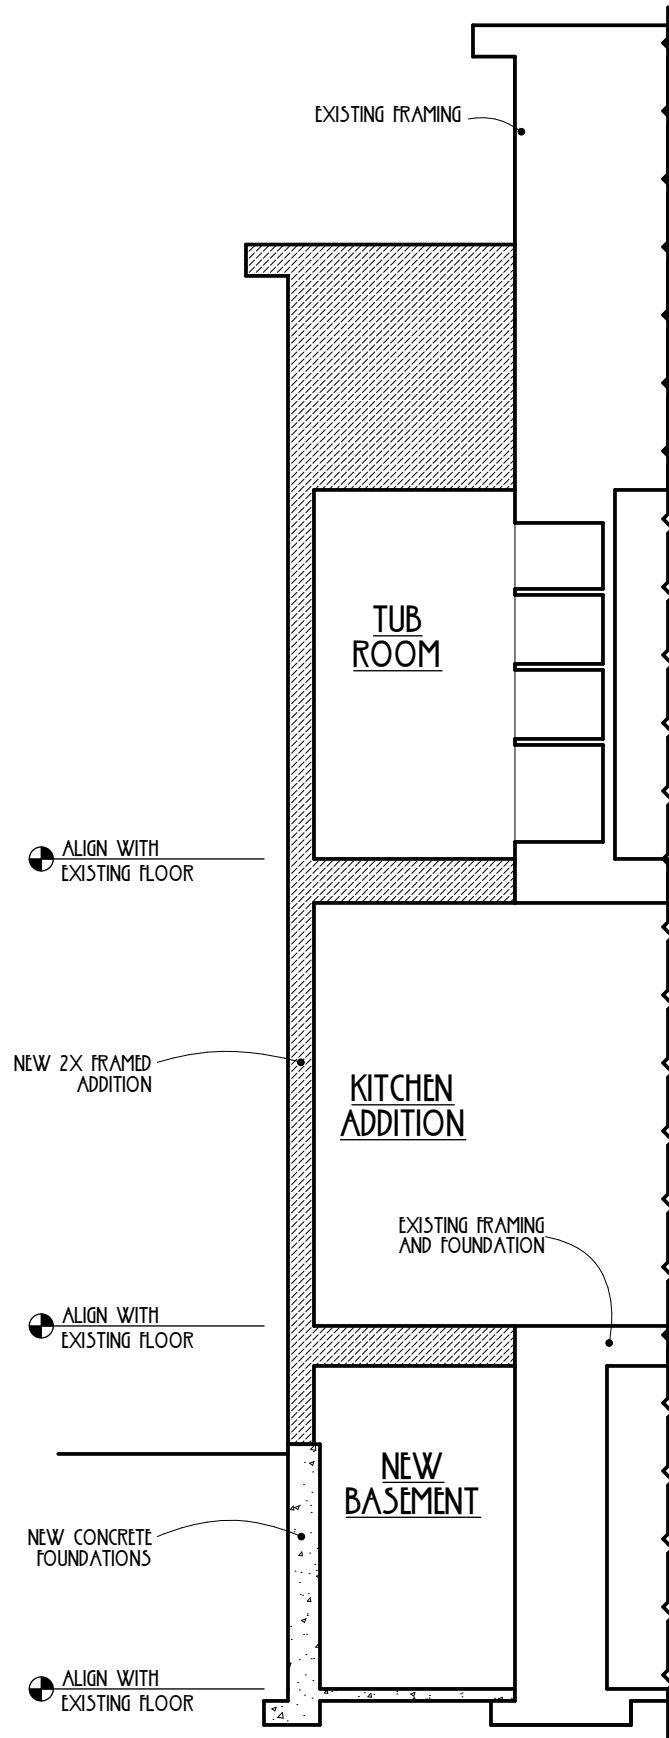


3 SECTION
SCALE 1/4" = 1'-0"

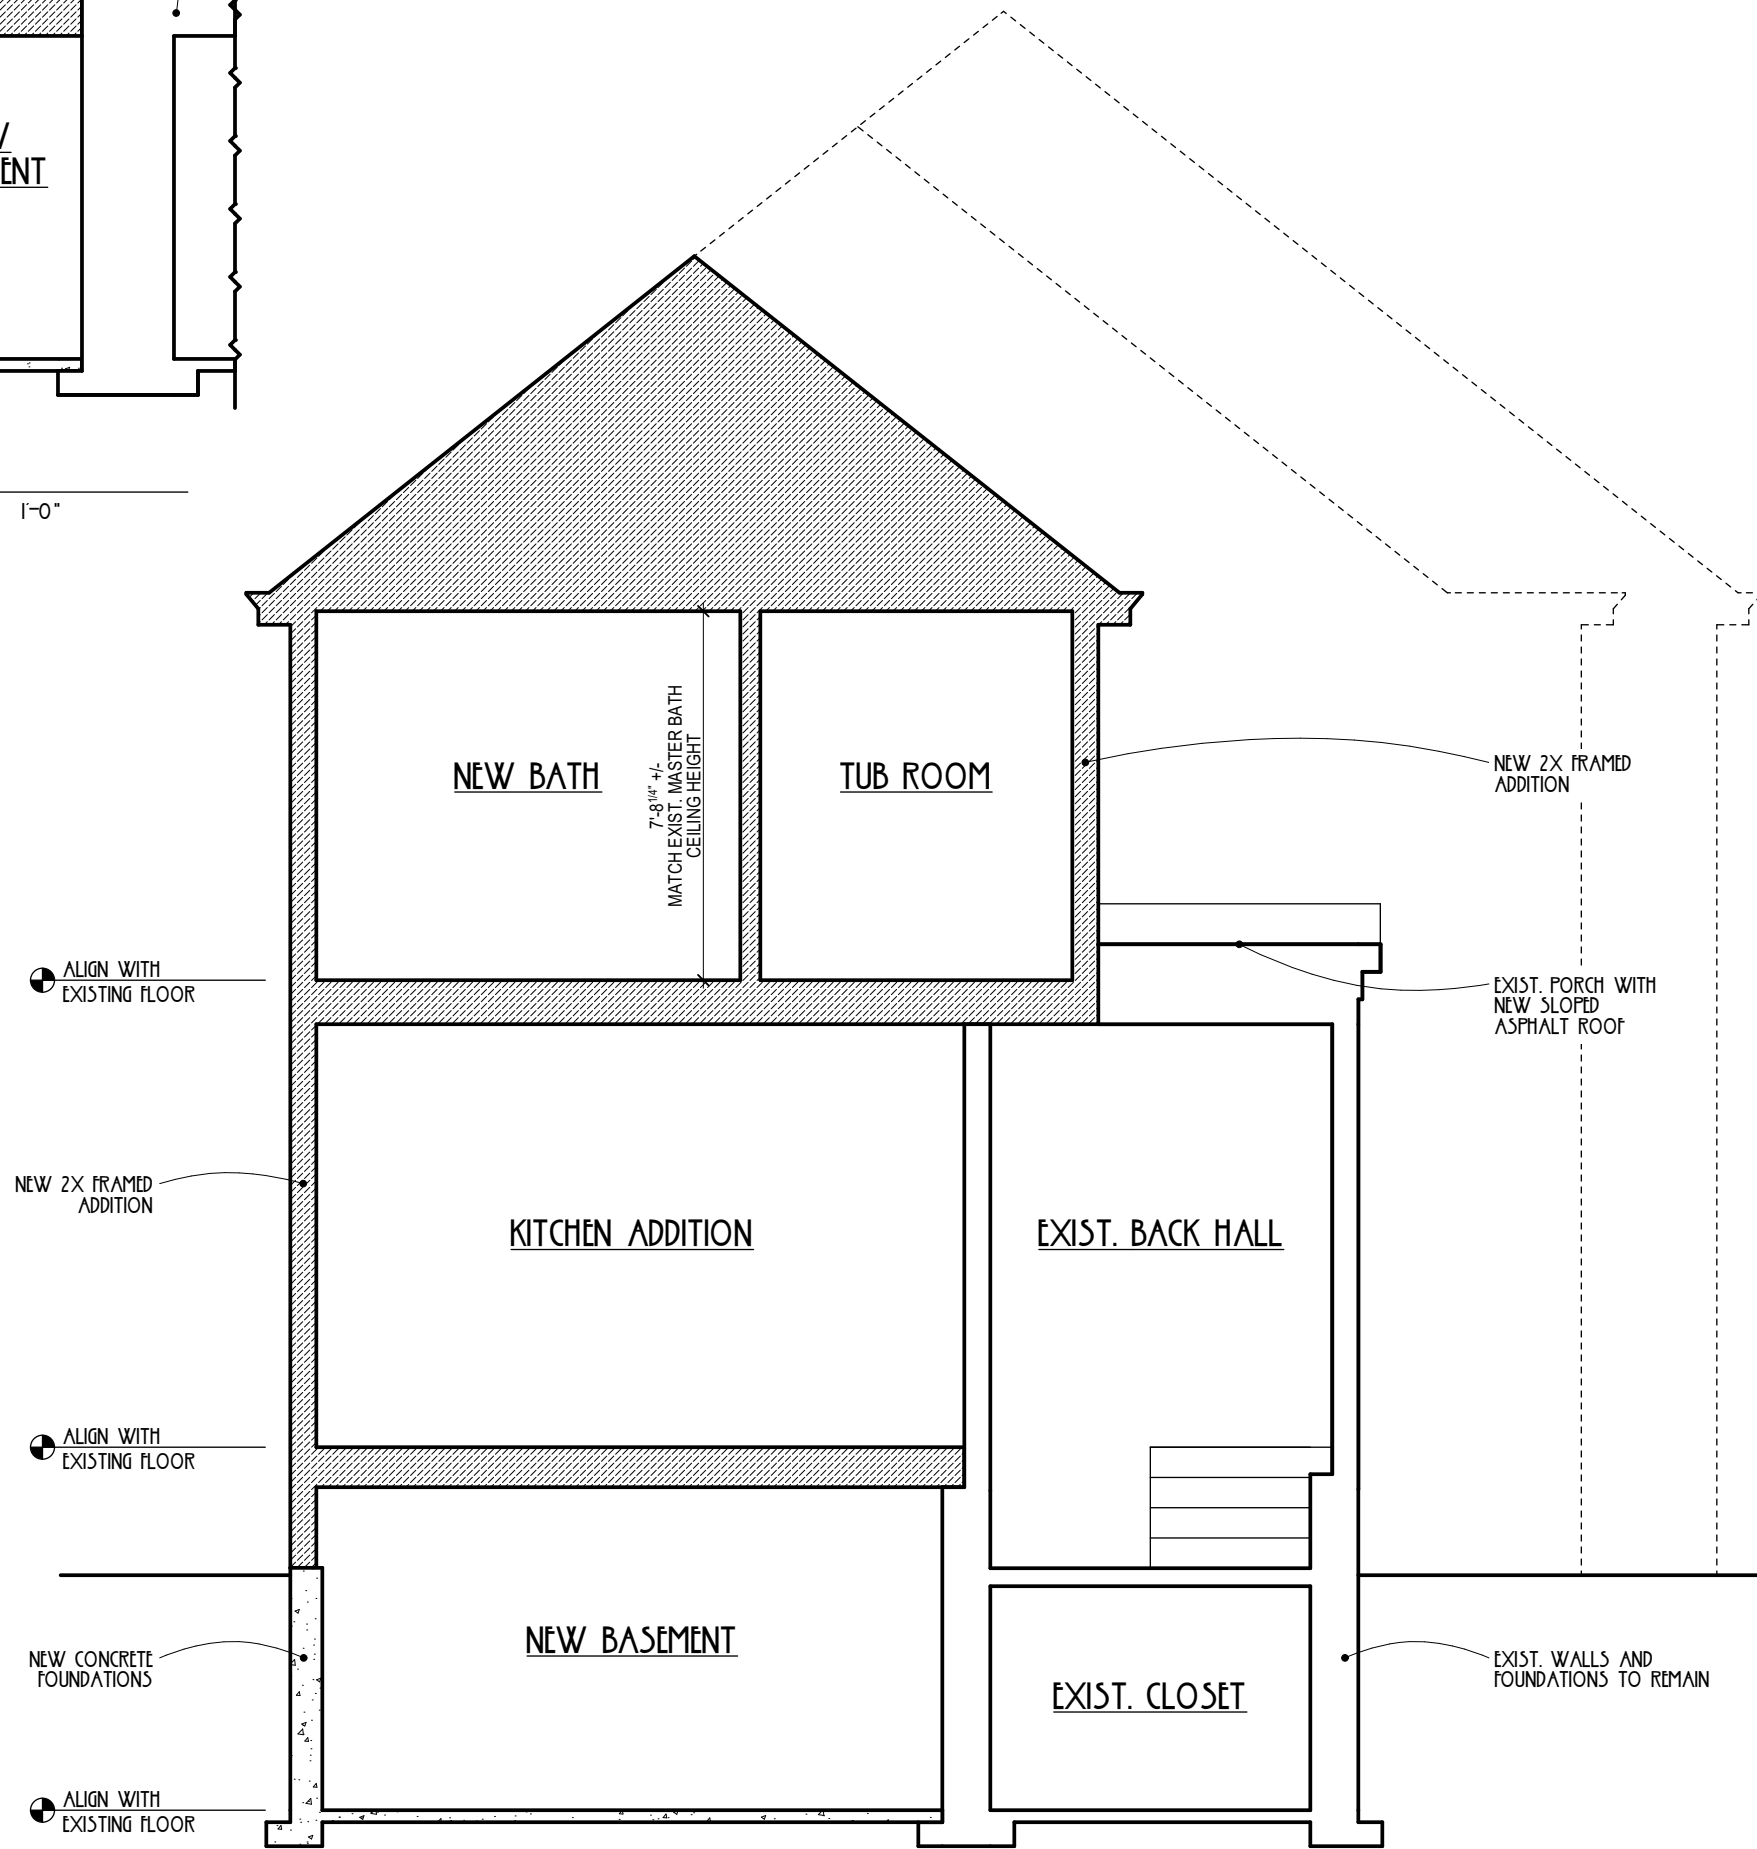


2 OVERALL SECTION
SCALE 1/4" = 1'-0"


EXTERIOR ELEVATION NOTES			
01	NEW WOOD SIDING WITH CORNER BOARDS TO MATCH EXISTING	06	STUCCO OVER CEMENT BOARD. TEXTURE TO MATCH EXISTING
02	NEW ASPHALT ROOF SHINGLES TO MATCH EXISTING	07	LOWER 2X TRIMS - MATCH EXISTING
03	NEW WINDOWS WITH TRIM TO MATCH EXISTING		
04	RAKE & TRIM TO MATCH EXISTING		
05	GUTTER AND RETURN WITH CROWN AND TRIM ON SOFFIT - MATCH EXISTING		
			SHADED AREA INDICATES EXISTING MATERIALS TO REMAIN

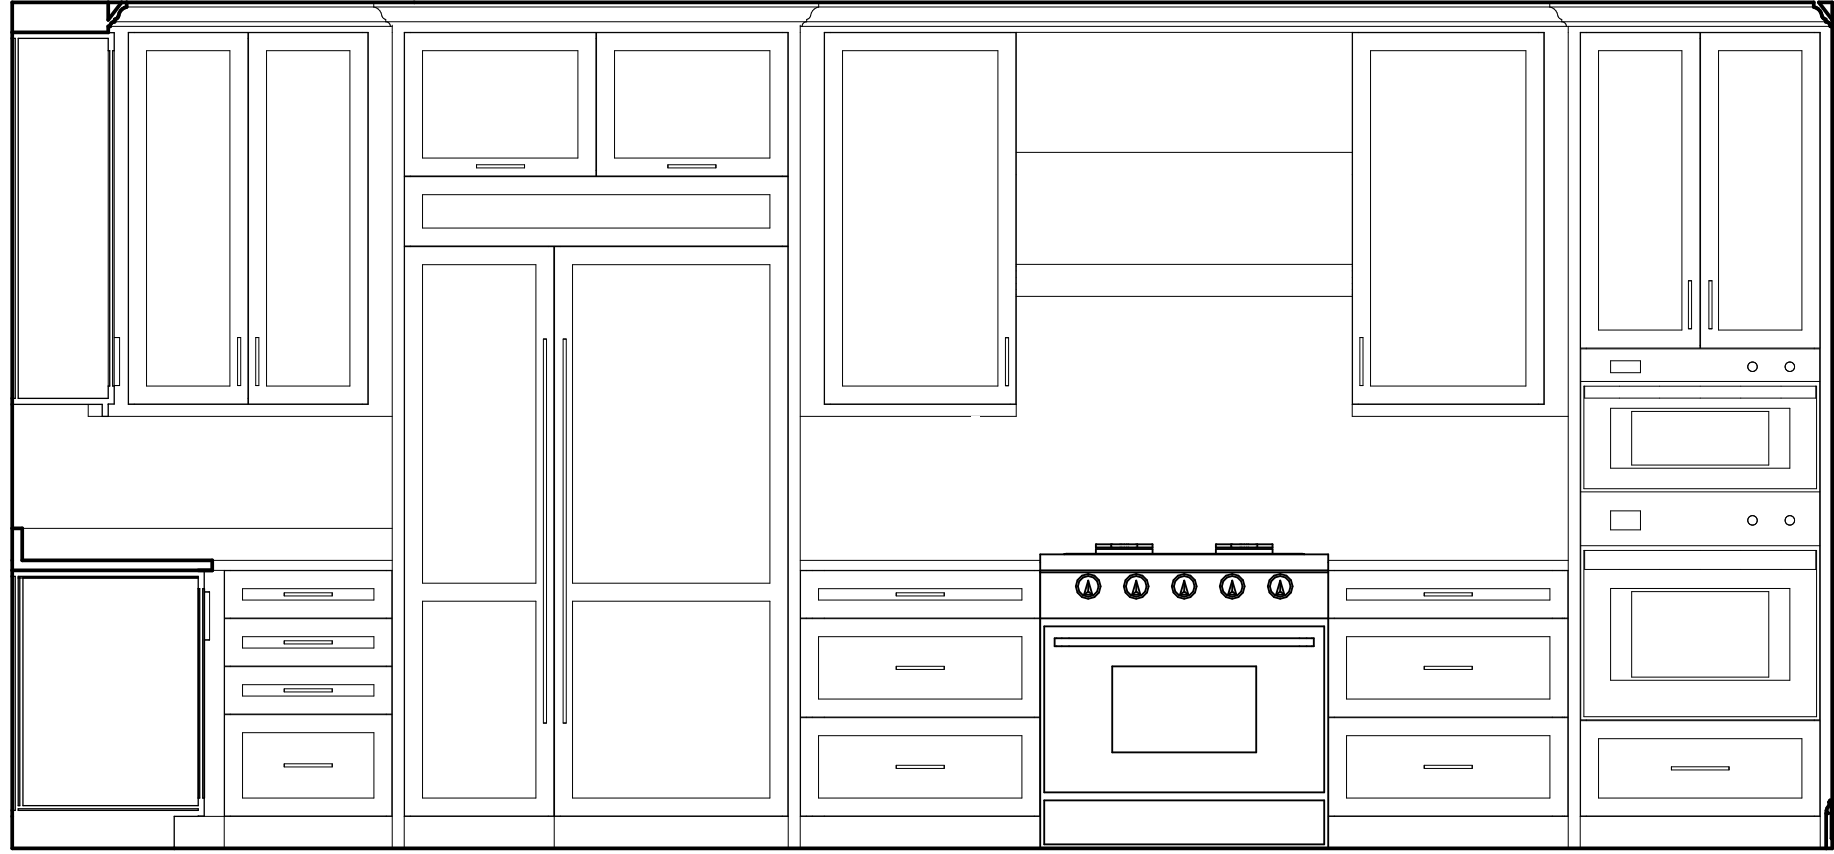


1 KITCHEN NORTH
SCALE 1/2" = 1'-0"

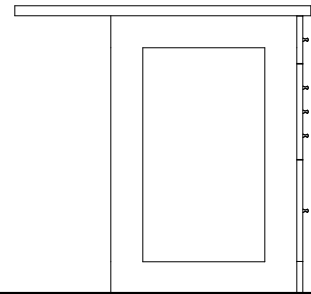


2 KITCHEN ISLAND SIDE
SCALE 1/2" = 1'-0"

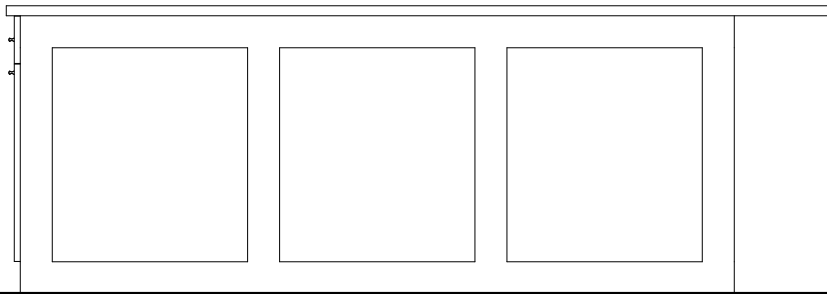


3 ISLAND BACK
SCALE 1/2" = 1'-0"

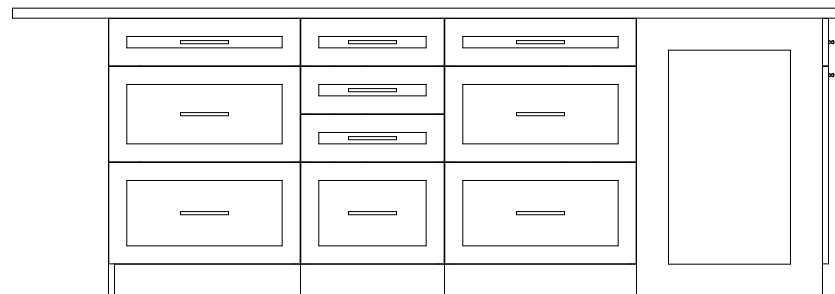

4 KITCHEN ISLAND FRONT
SCALE 1/2" = 1'-0"

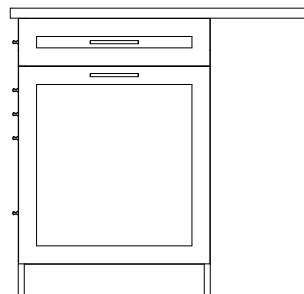

5 ISLAND SIDE
SCALE 1/2" = 1'-0"

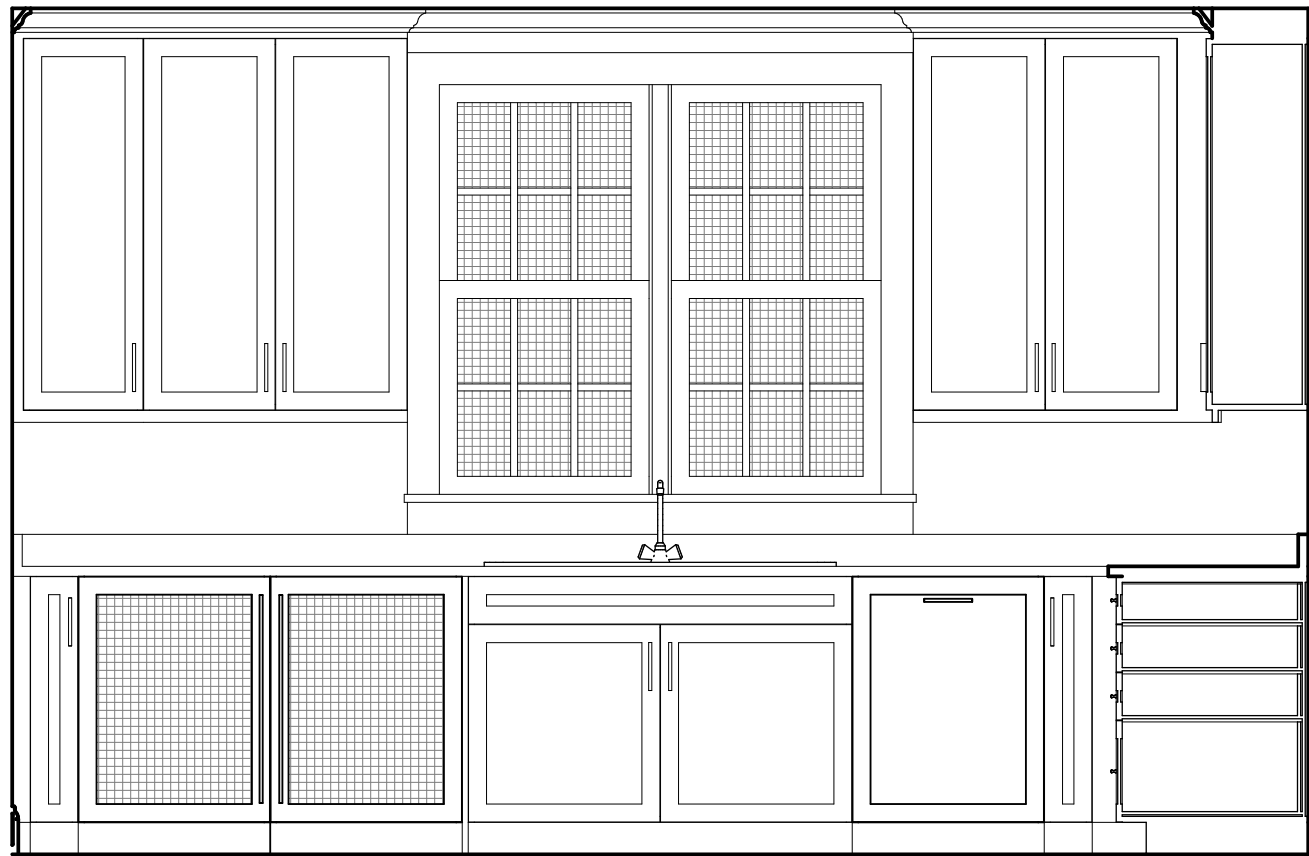

6 KITCHEN WEST
SCALE 1/2" = 1'-0"



7 KITCHEN SOUTH
SCALE 1/2" = 1'-0"

DATE: 14 AUG. 2025
DESCRIPTION: CHURCH ST ADDITION
REVIEW SET

INTERIOR ELEVATIONS

Copyright © 2025 Pen & Hammer, LLC. All Rights Reserved. This document, its design, and its content are the property of Pen & Hammer, LLC. No part of this document may be reproduced, stored in a retrieval system, or transmitted in any form or by any means, electronic, mechanical, or otherwise, without the express written consent of Pen & Hammer, LLC. These drawings are created by The Architectural Works Company, Inc. and are the property of The Architectural Works Company, Inc.

A61

A L A I R




CUSTOM HOMES · RENOVATIONS



P E N & H A M M E R


R

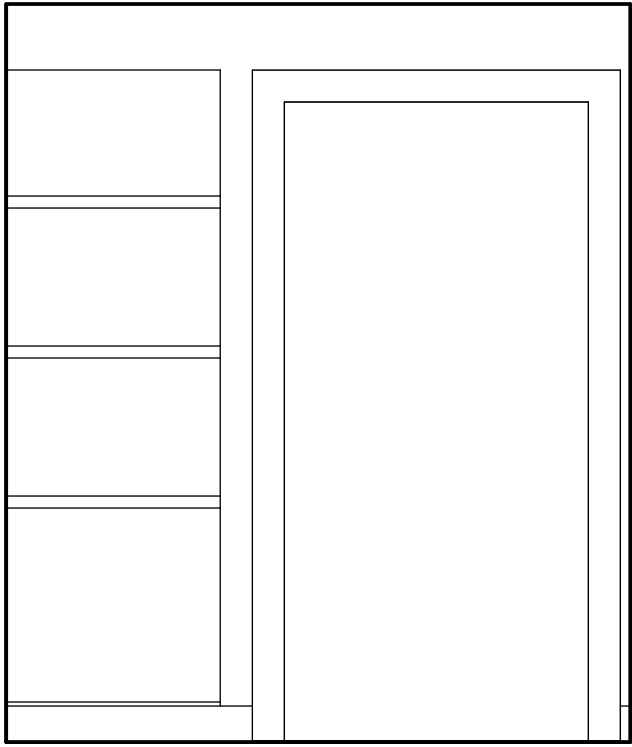

7

TUB ROOM


SCALE 1/2" = 1'-0"

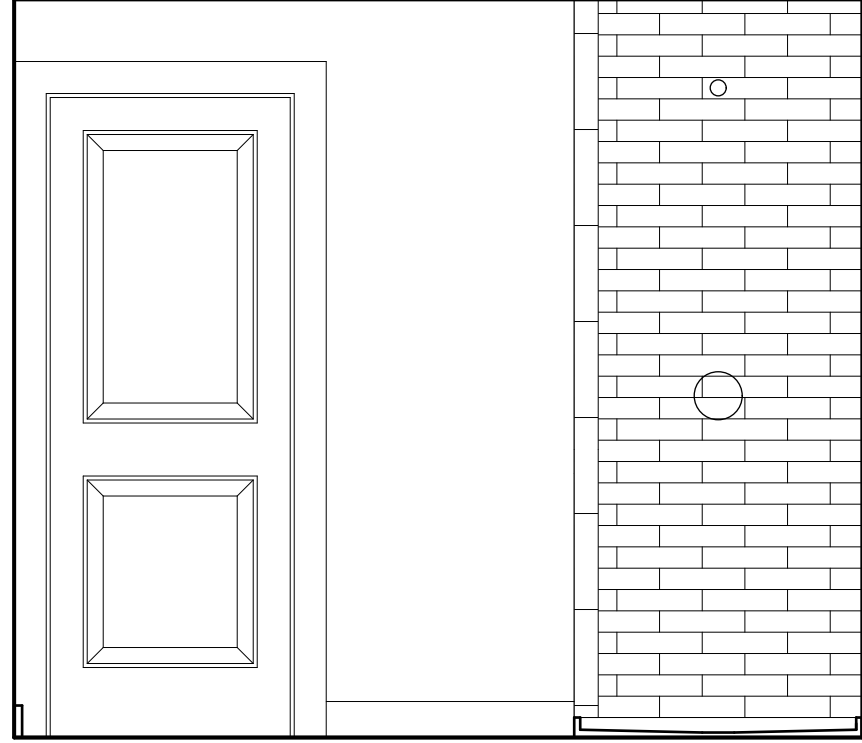

4

SHOWER WALL


SCALE 1/2" = 1'-0"

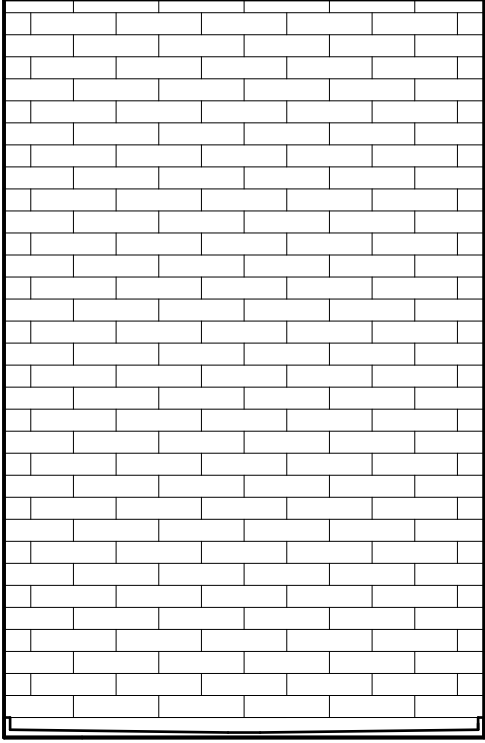

5

SHOWER WALL


SCALE 1/2" = 1'-0"

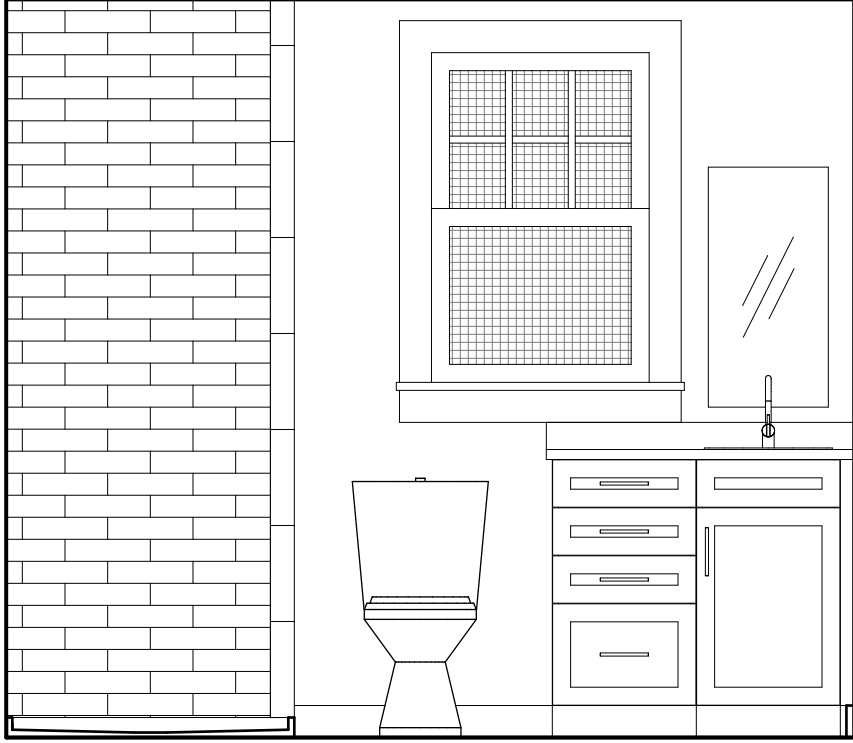

6

TOILET WALL


SCALE 1/2" = 1'-0"

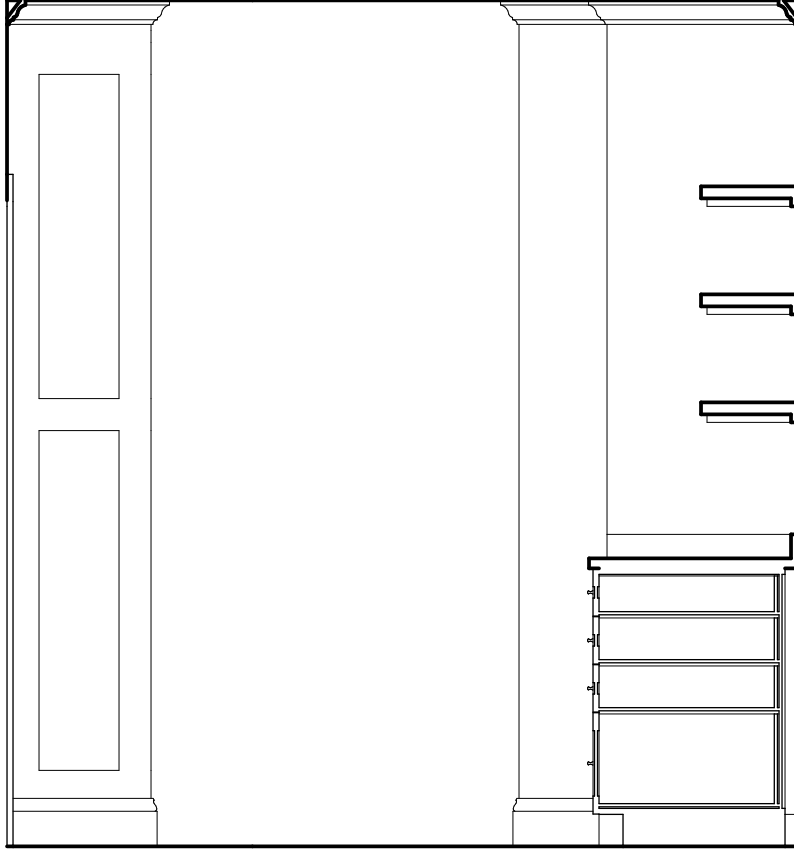

3

CUBBY SIDE & SHELVES


SCALE 1/2" = 1'-0"

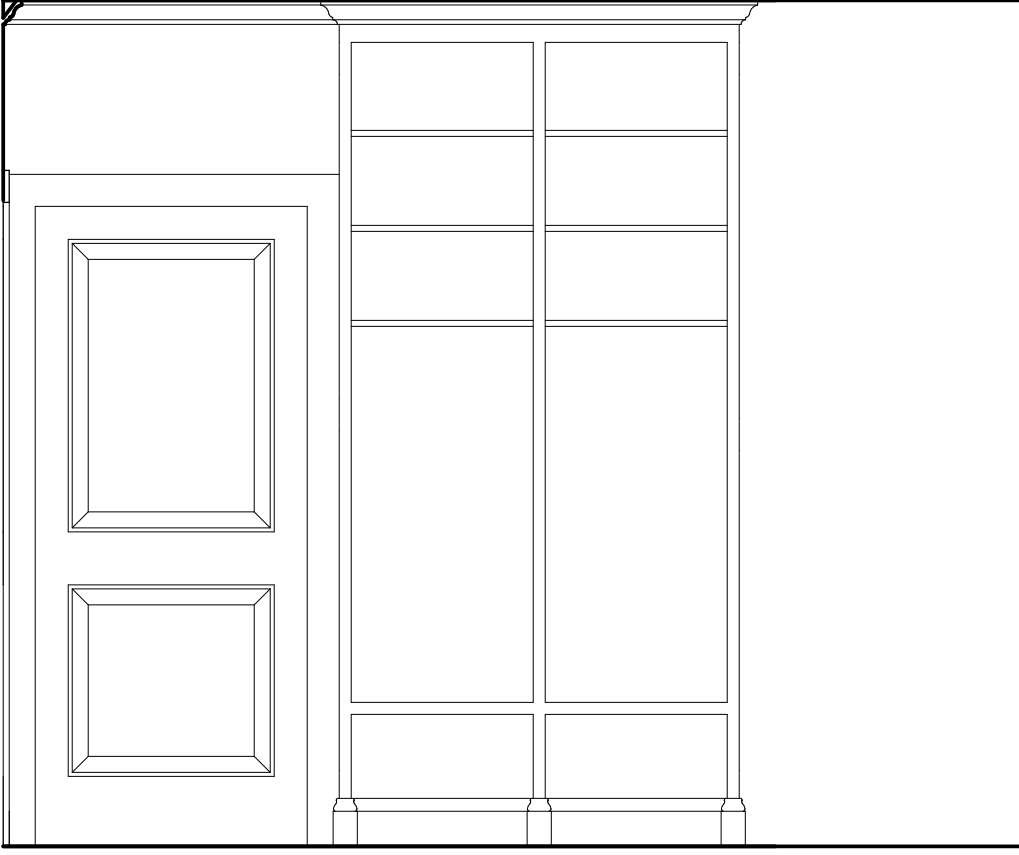

2

CUBBIES


SCALE 1/2" = 1'-0"

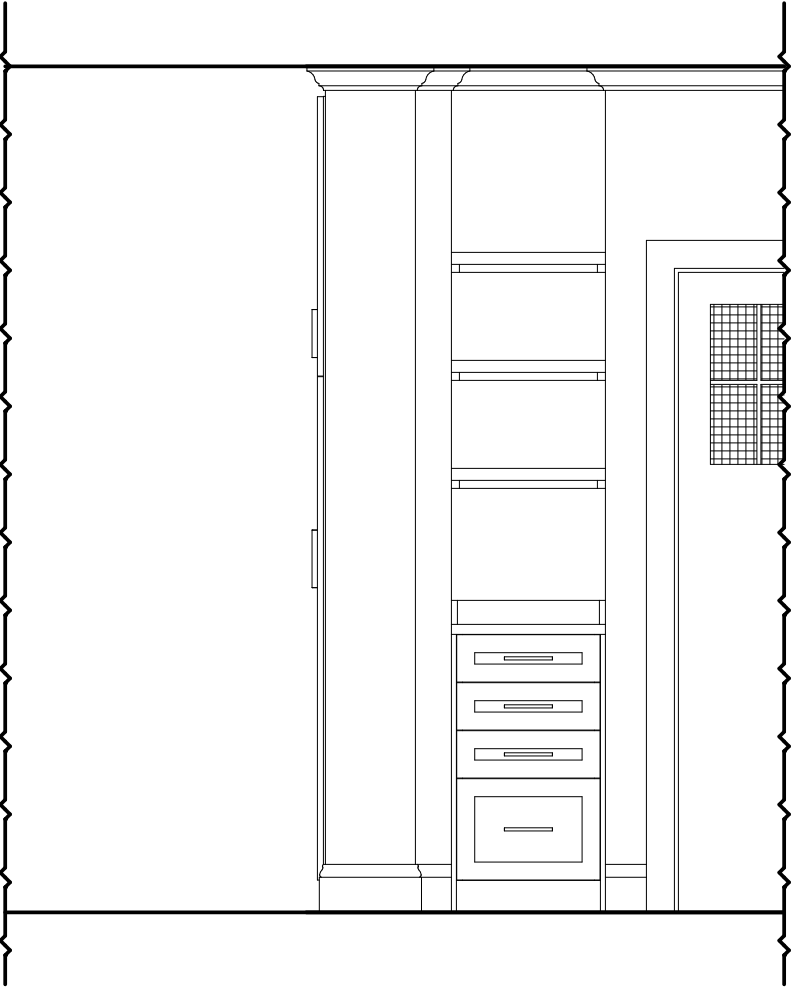


1

DROP ZONE

SCALE 1/2" = 1'-0"

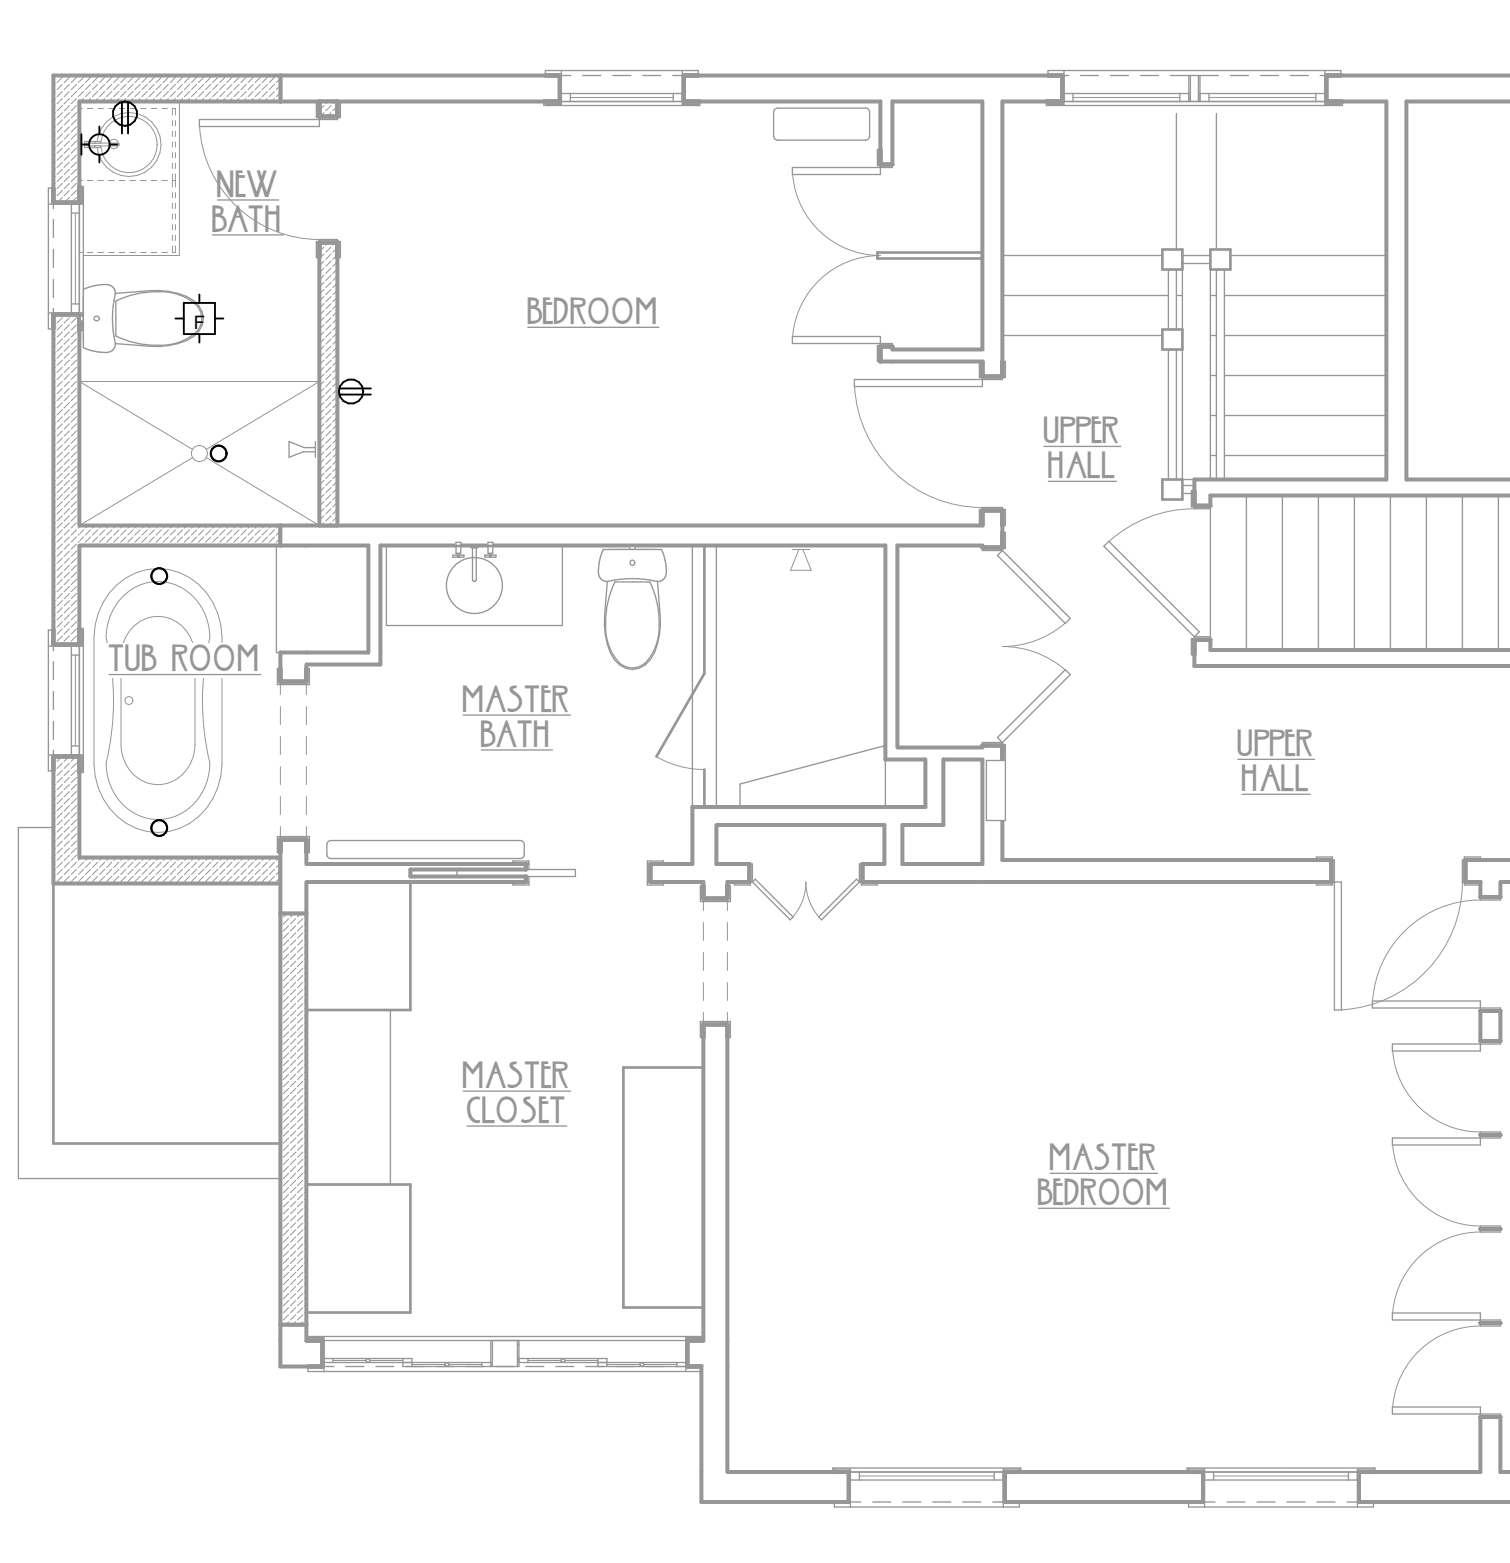


3 SECOND FLOOR ELECTRICAL PLAN

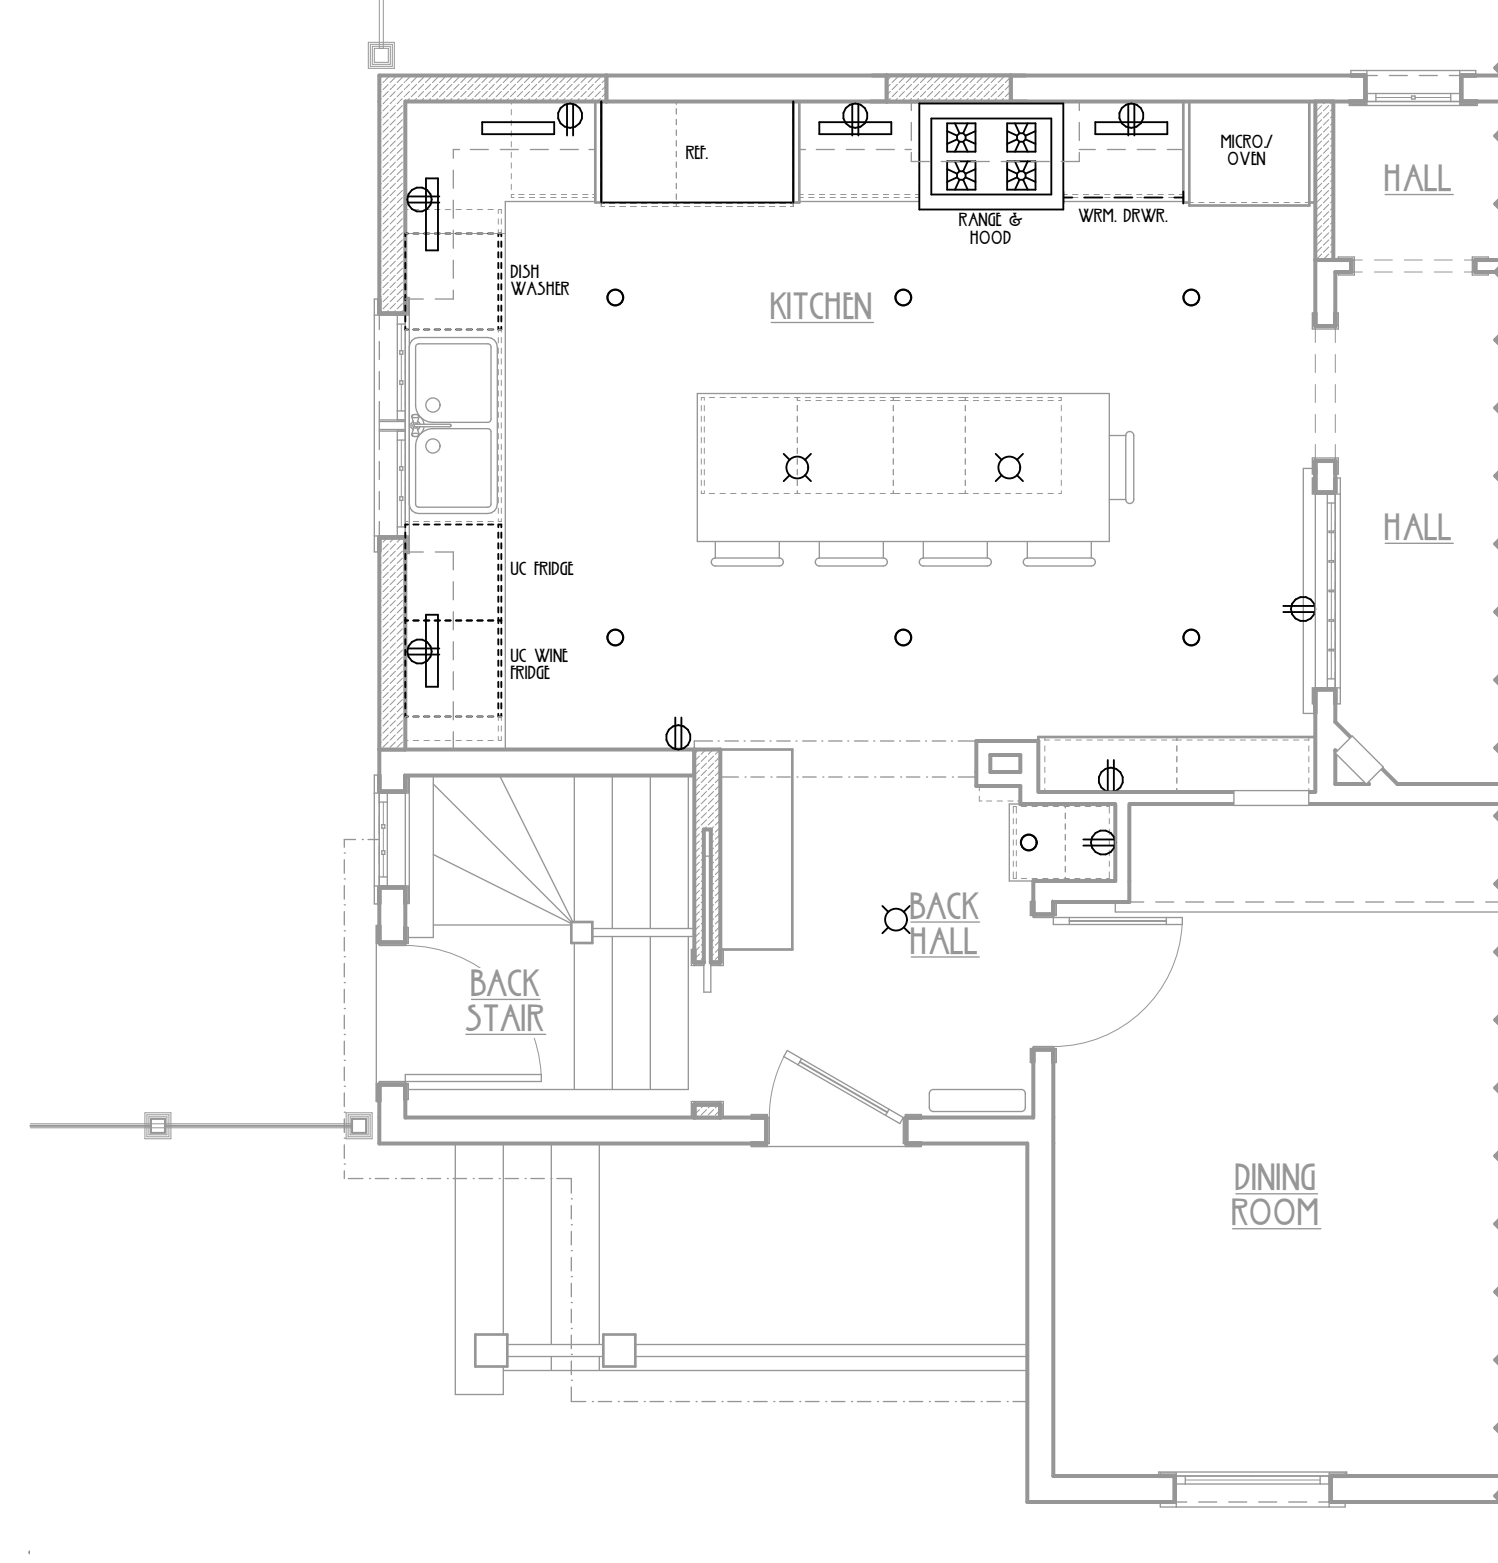

2 FIRST FLOOR ELECTRICAL PLAN

SCALE: 1/4" = 1'-0"

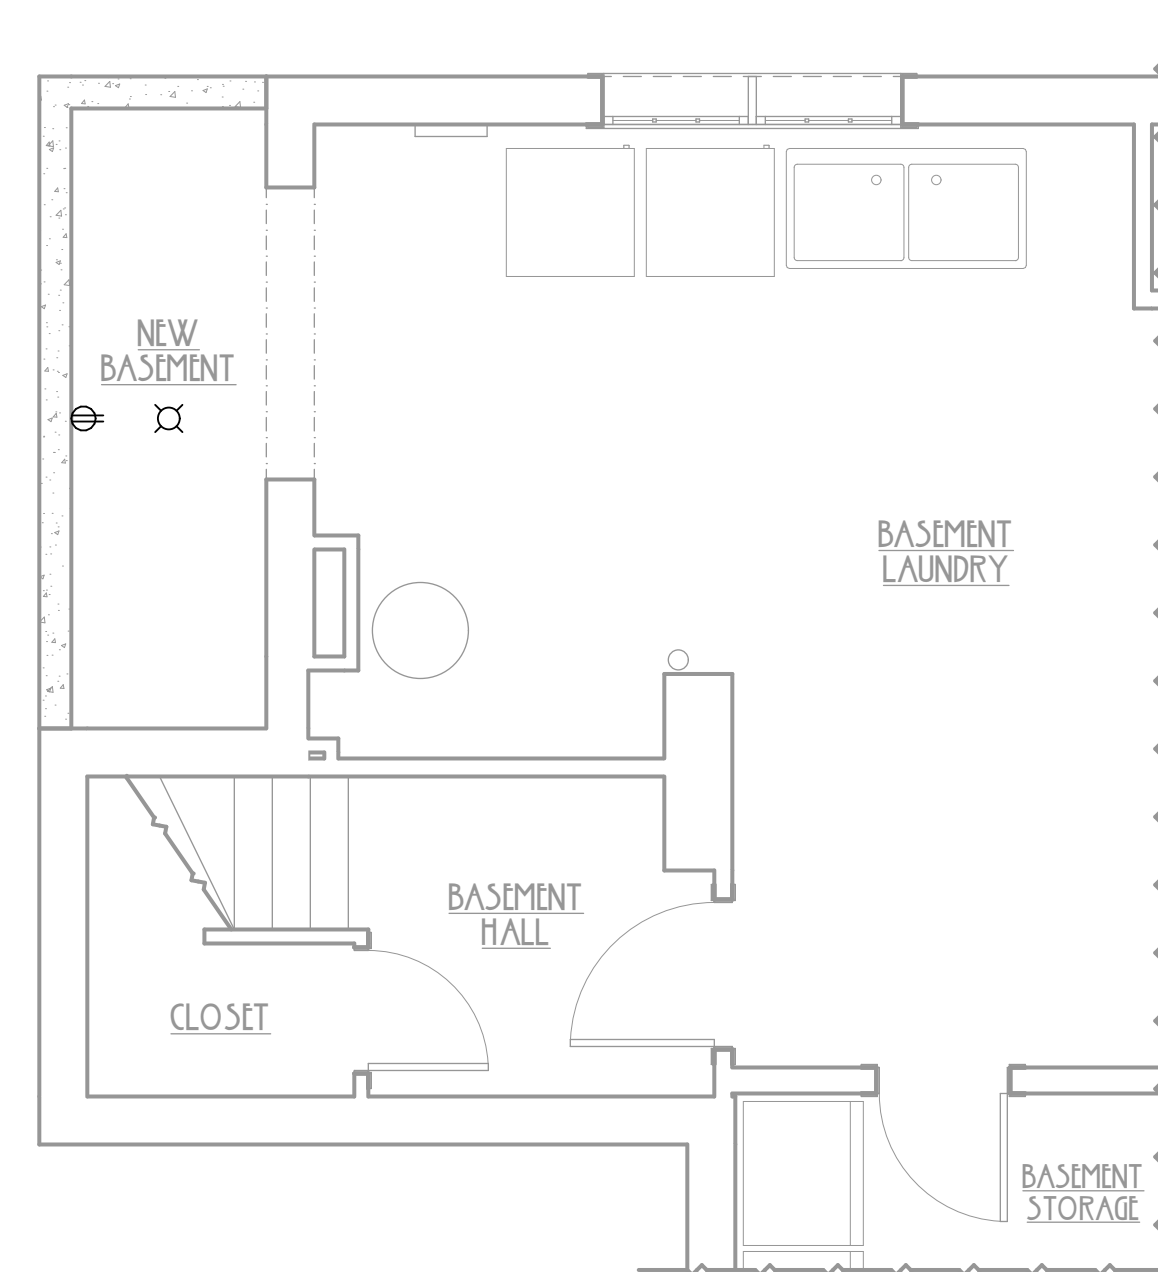

1 LOWER LEVEL ELECTRICAL PLAN
SCALE: 1/4" = 1'-0"

<

